




ACTUAL PERSPECTIVE VIEW
SCALE N.T.S.

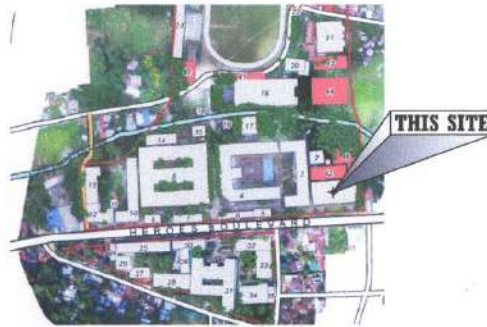






VICINITY MAP
SCALE N.T.S.




SITE DEVELOPMENT PLAN
SCALE N.T.S.

ADMINISTRATION BUILDING

REPUBLIC OF THE PHILIPPINES DEPARTMENT OF PUBLIC WORKS & HIGHWAYS TRANSPORTATION & COMMUNICATION	
OFFICE OF THE BUILDING OFFICIAL	
DISTRICT/ CITY/ MUNICIPALITY	
LAND USE AND ZONING	
LINE AND GRADE	
ARCHITECTURAL	
STRUCTURAL	
ELECTRICAL	
PLUMBING / SANITARY	
TABLE OF CONTENTS	
A-18	-PROPOSED PLAN (LADIES' CR) -PERSPECTIVES -REFLECTED CEILING PLAN -CEILING FRAMING PLAN
A-19	-SECTIONS (LADIES' CR) -SCHEDULE OF DOORS & WINDOWS (C)
P-10	-SANITARY LINE LAYOUT -WATER LINE LAYOUT
P-11	-ISOMETRIC LAYOUT
SUPPLY OFFICE CR	
A-20	-AS-BUILT PLAN & PROPOSED PLAN -REFLECTED CEILING PLAN -CEILING FRAMING PLAN -SECTION -SCHEDULE OF DOORS & WINDOWS (D)
P-12	-SANITARY LINE LAYOUT -WATER LINE LAYOUT
P-13	-ISOMETRIC LAYOUT
RESEARCH OFFICE CR	
A-21	-AS-BUILT PLAN & PROPOSED PLAN -REFLECTED CEILING PLAN -CEILING FRAMING PLAN -SECTION -SCHEDULE OF DOORS & WINDOWS (E)
P-14	-SANITARY LINE LAYOUT -WATER LINE LAYOUT -ISOMETRIC LAYOUT
GUEST ROOM CR	
A-22	-AS-BUILT PLANS -ACTUAL SITE DOCUMENTATION -PROPOSED PLAN -PERSPECTIVES
A-23	-SECTIONS
A-24	-REFLECTED CEILING PLAN -CEILING FRAMING PLAN -SCHEDULE OF DOORS & WINDOWS
P-15	-SANITARY LINE LAYOUT -WATER LINE LAYOUT
P-16	-ISOMETRIC LAYOUT
STRUCTURAL	
S-1	-WALL FOOTING DETAILS
S-2	-TROUGH SINK DETAILS
ELECTRICAL	
E-1	-GROUND FLOOR LIGHTING LAYOUT
E-2	-SECOND & THIRD FLOOR LIGHTING LAYOUT
COMMON CR (GROUND FLOOR)	
A-10	-AS-BUILT PLANS -ACTUAL SITE DOCUMENTATION
A-11	-PROPOSED PLAN (MEN'S CR) -PERSPECTIVES -REFLECTED CEILING PLAN -CEILING FRAMING PLAN
A-12	-SECTIONS (MEN'S CR)
P-4	-SANITARY LINE LAYOUT -WATER LINE LAYOUT
P-5	-ISOMETRIC LAYOUT
A-13	-PROPOSED PLAN (LADIES' CR) -PERSPECTIVES -SECTIONS
A-14	-SECTIONS (LADIES' CR) -REFLECTED CEILING PLAN -CEILING FRAMING PLAN -COVE LIGHT DETAILS
P-6	-SANITARY LINE LAYOUT -WATER LINE LAYOUT
P-7	-ISOMETRIC LAYOUT
COMMON CR (SECOND FLOOR)	
A-15	-AS-BUILT PLANS -ACTUAL SITE DOCUMENTATION
A-16	-PROPOSED PLAN (MEN'S CR) -PERSPECTIVES -REFLECTED CEILING PLAN -CEILING FRAMING PLAN
A-17	-SECTIONS (MEN'S CR)
P-8	-SANITARY LINE LAYOUT -WATER LINE LAYOUT
P-9	-ISOMETRIC LAYOUT

     SIGNED AND SEALED BY:	PROJECT AND LOCATION:	PREPARED BY:	SUBMITTED BY:	CONCURRED BY:	RECOMMENDING APPROVAL:	APPROVED BY:	SHEET NO:	
PRC REG NO. _____ VALID UNTIL _____ PTR NO. _____ VALID UNTIL _____ PLACE OF ISSUE: _____ DATE ISSUE: _____ TIN NO. _____	 REPAIR/ IMPROVEMENT OF COMFORT ROOMS NUEVA VIZCAYA STATE UNIVERSITY BAMBANG CAMPUS	 DENNIS RIO C. VALDEZ Architect	 JENNIE ROSE J. MORANTE Architect	 JYRUS MILES CADIENTE Director, PPSDB	 GERALD L. PEREZ Campus Administrator	 CARLO F. VADIL VP for Planning, Development and Information System	 WILFREDO A. DUMALE, JR. University President	A 1 24

SIGNED AND SEALED BY:	PROJECT AND LOCATION:	PREPARED BY:	SUBMITTED BY:	CONCURRED BY:	RECOMMENDING APPROVAL:	APPROVED BY:	SHEET NO:
 PRC REG NO: _____ VALID UNTIL: _____ PTR NO: _____ VALID UNTIL: _____ PLACE OF ISSUE: _____ DATE OF ISSUE: _____	REPAIR/ IMPROVEMENT OF COMFORT ROOMS NUJUA VIZDAYA STATE UNIVERSITY, BAMBANG CAMPUS	 DENNIS RIO L. VALDEZ Architect  JENNIE ROSE J. MORANTE Artist	 OFELIA S. RUBIO JYRUS J. F. CADIENTE Director, FPSDS	 GERALD L. PEREZ Campus Administrator	 CARL O. F. VADIL VP for Planning, Management and Information System	 WILFREDO A. DUMALE, JR University President	

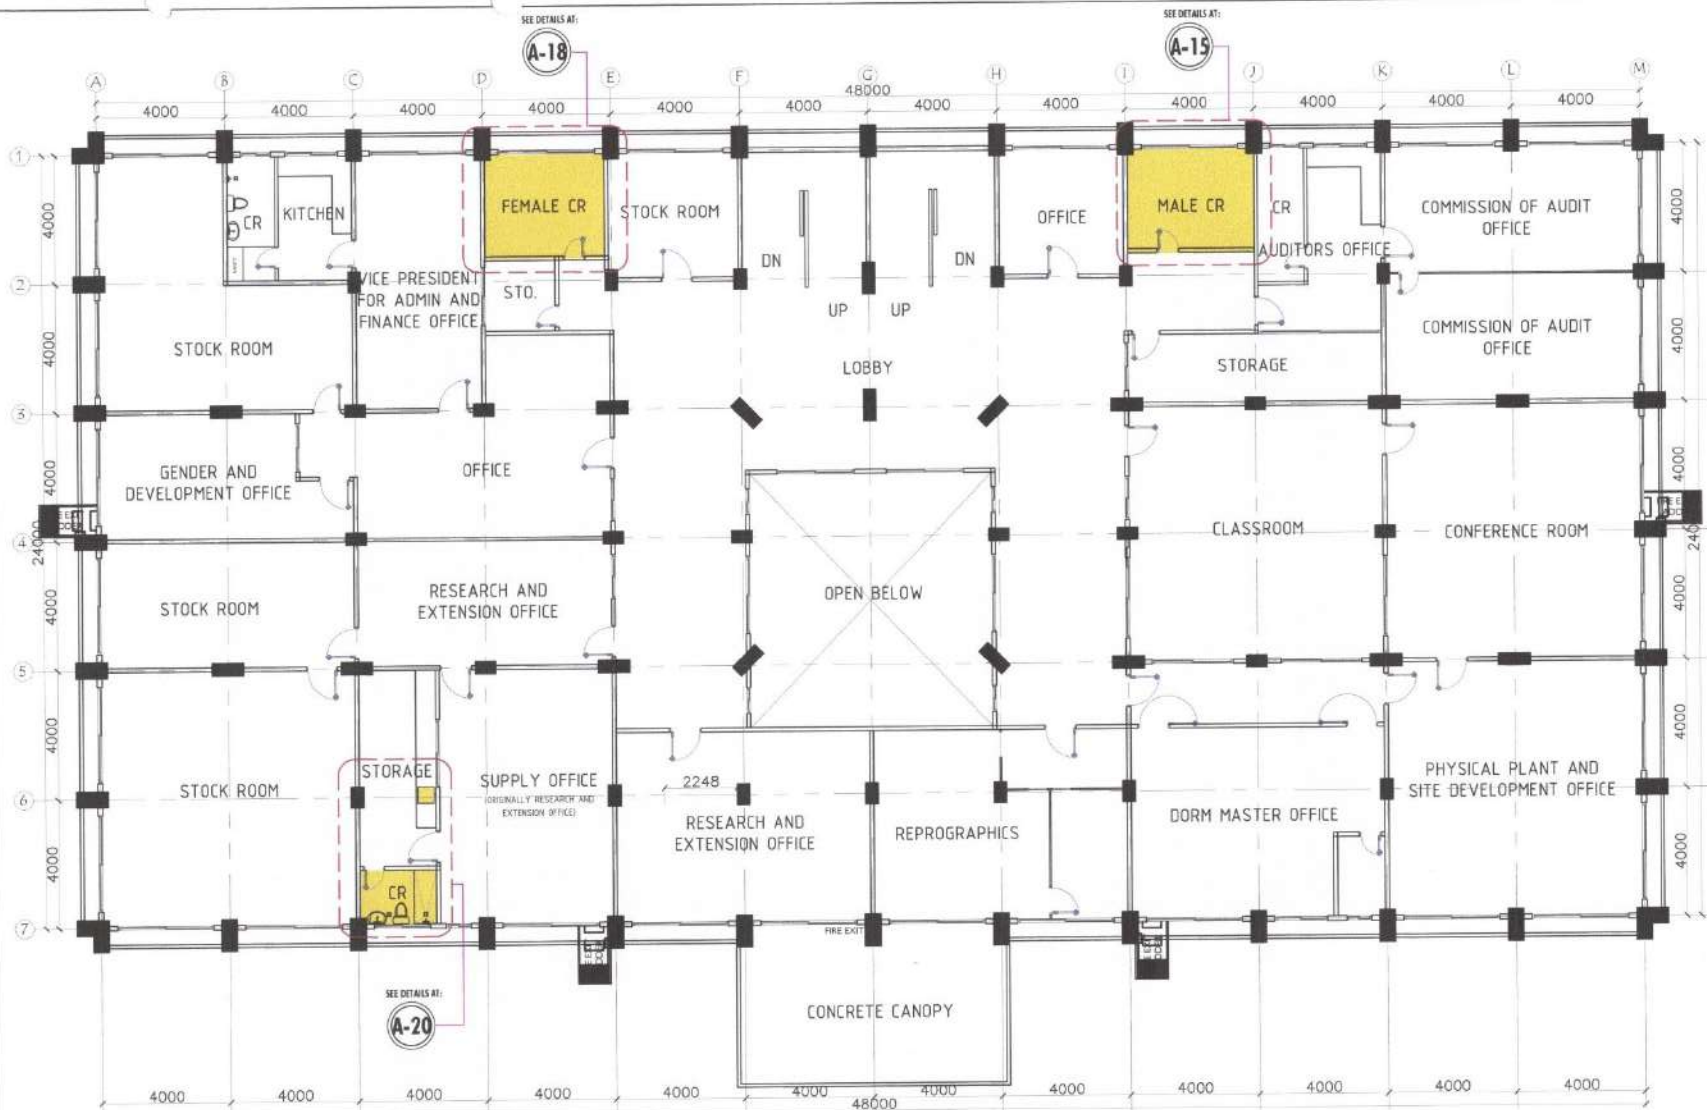

SIGNED AND SEALED BY:

PROJECT AND LOCATION:

PREPARED BY:

SUBMITTED BY:

CONCURRED BY:

RECOMMENDING APPROVAL:

APPROVED BY:

SHEET NO:

PRC REG NO: _____ VALID UNTIL: _____
PTR NO: _____ VALID UNTIL: _____
PLACE OF ISSUE: _____ DATE OF ISSUE: _____
TINAG: _____



**REPAIR/ IMPROVEMENT OF
COMFORT ROOMS**

NUUEVA VIZCAYA STATE UNIVERSITY,
BAMBANG CAMPUS

DENNIS RICO C. VALDEZ
Architect

JENNIE ROSE J. MORANTE
Architect


OPHELIA S. RUBIO
JYRUS JYLES CADIENTE
Director, PPRCS

GERALD L. PEREZ
Campus Administrator

CARLO F. VADIL
VP for Planning, Development and Information System

WILFREDO A. DUMALE, JR.
University President

A 3
24

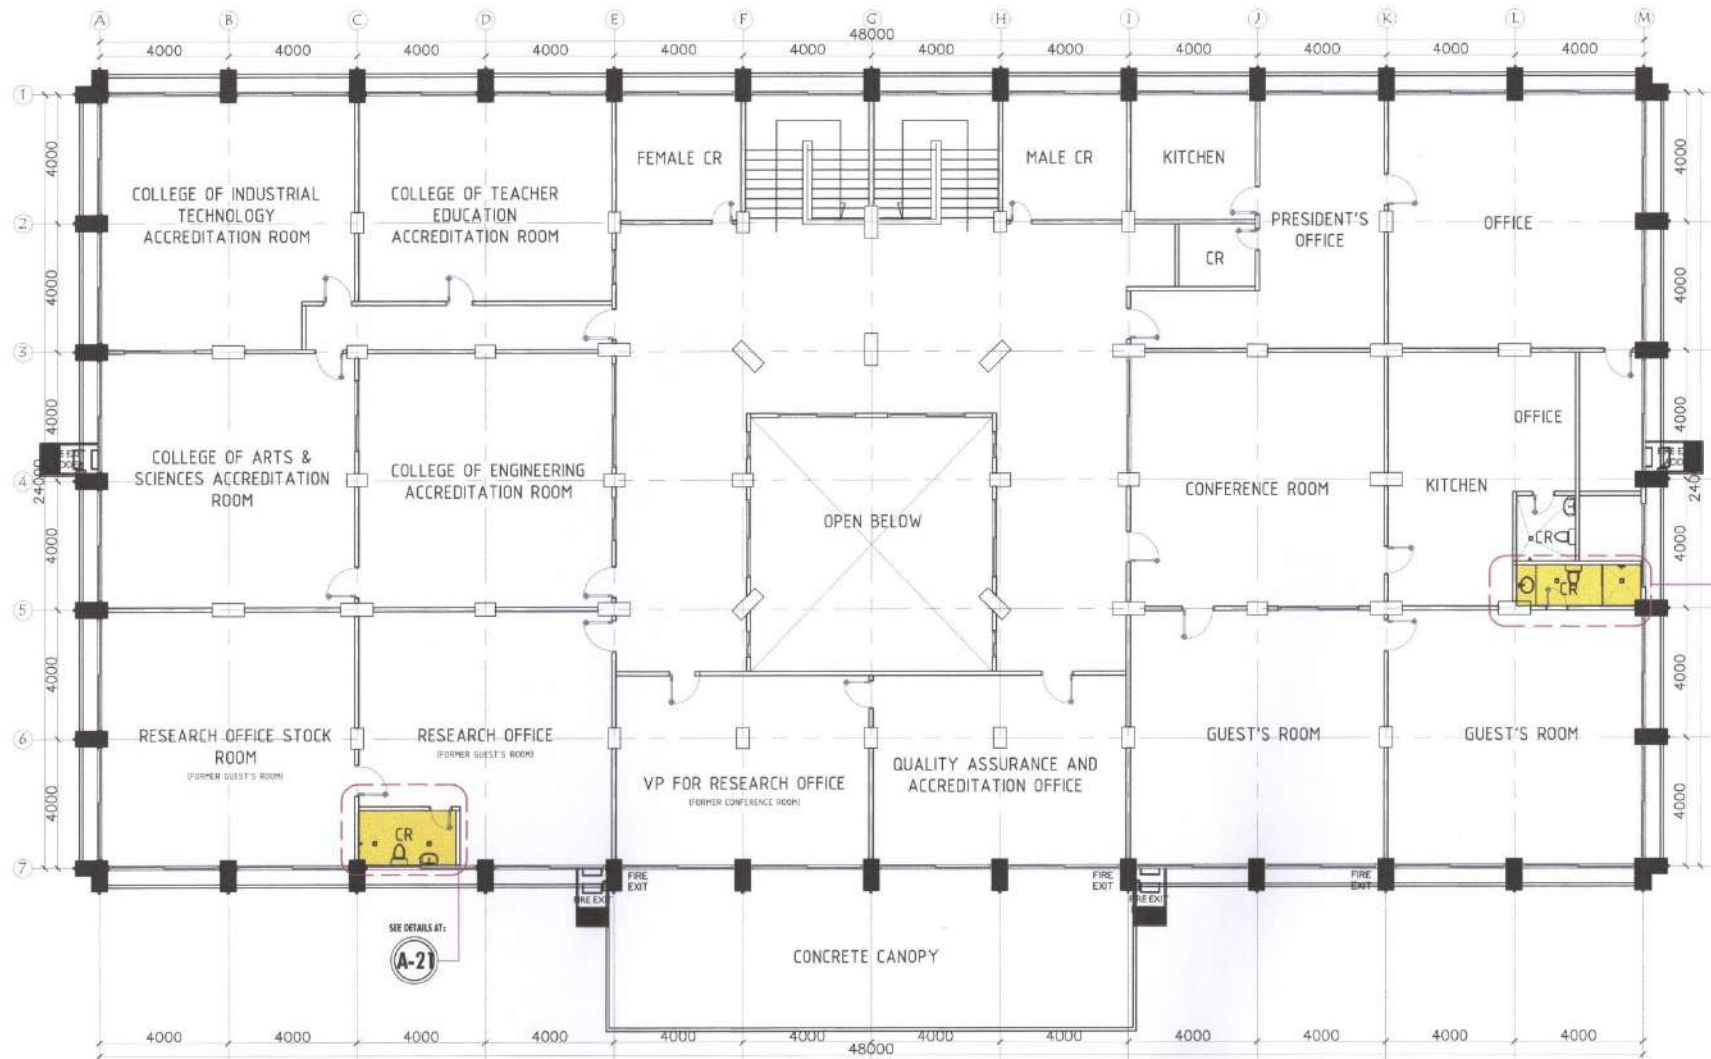

ADMINISTRATION BUILDING

THIRD FLOOR PLAN

SCALE 1/150M

SIGNED AND SEALED BY:

PROJECT AND LOCATION:

PREPARED BY:

SUBMITTED BY:

CONCURRED BY:

RECOMMENDING APPROVAL:

APPROVED BY:

SHEET NO:

PRG REG NO: _____ VALID UNTIL: _____
PTR NO: _____ VALID UNTIL: _____
PLACE OF ISSUE: _____ DATE ISSUE: _____
TRV NO: _____



REPAIR/IMPROVEMENT OF COMFORT ROOMS
NUEVA VIZCAYA STATE UNIVERSITY,
BAMBANG CAMPUS

DENNIS RICO VALDEZ

JENNIE ROSE J. MORANTE

OFELIA S. RUBIO
JYRUS J. CADIENTE
Director, PPSDS

GERALD L. PEREZ
Campus Administrator

CARLO F. VADIL
VP for Planning, Development and Information System

WILFREDO A. DUMALE, JR.
University President




A 4
24

REGISTRAR'S OFFICE CR




G R O U N D F L O O R



ACTUAL SITE

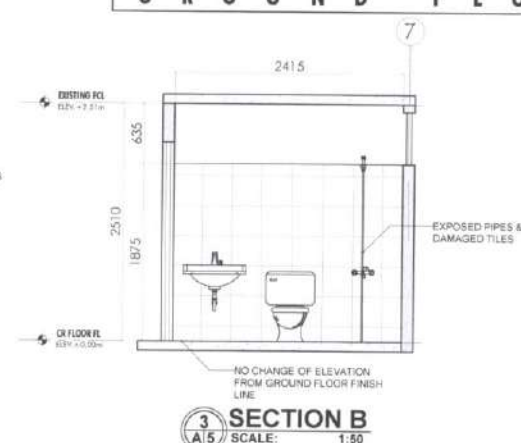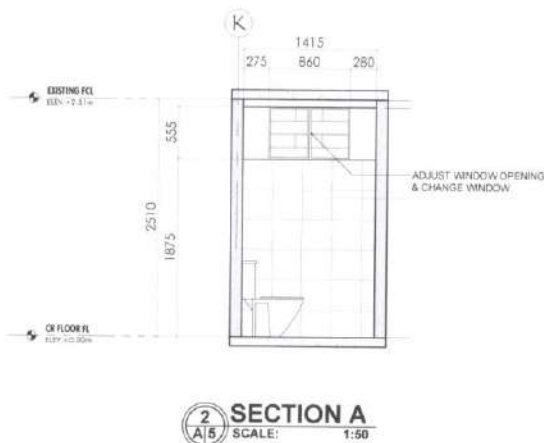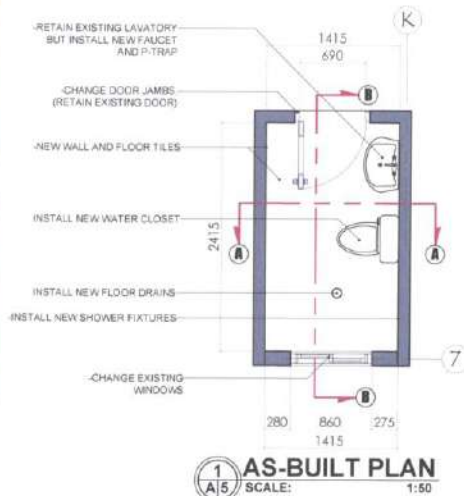

VISUALIZATION

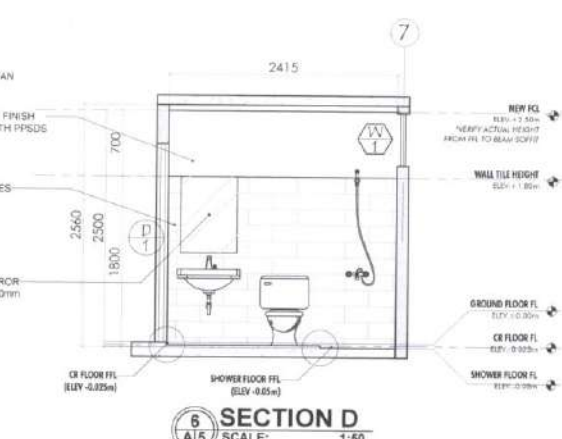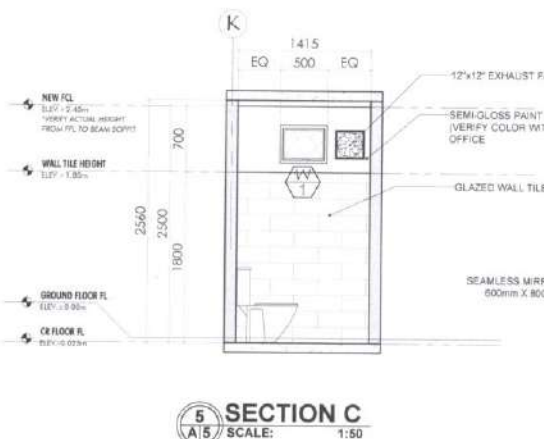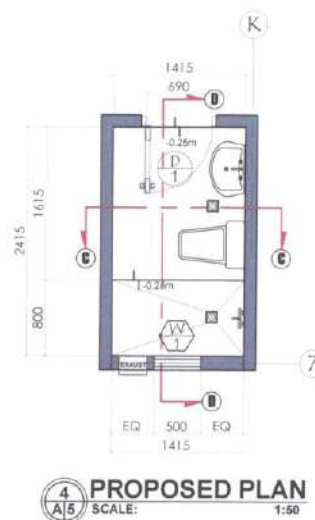

SIGNED AND SEALED BY:

PROJECT AND LOCATION:

PREPARED BY:

SUBMITTED BY:

CONCURRED BY:

RECOMMENDING APPROVAL:

APPROVED BY:

SHEET NO:

PRG REG NO. _____ VALID UNTIL _____
PTR NO. _____ VALID UNTIL _____
PLACE OF ISSUE _____ DATE ISSUE _____
TRN NO. _____



REPAIR/IMPROVEMENT OF COMFORT ROOMS
NUEVA VIZCAYA STATE UNIVERSITY
BAMBANG CAMPUS

DENNIS RIO C. VALDEZ
Architect

JENNIE ROSE J. MORANTE
Architect


OFELIA S. RUBIO
JYRUS APLES CADIENTE
Director - PPDS/CS

GERALD L. RENEZ
Campus Administrator


CARLO F. VADIL
VP for Planning, Development and Information System

WILFREDO A. DUMALE JR.
University President

A/5
24

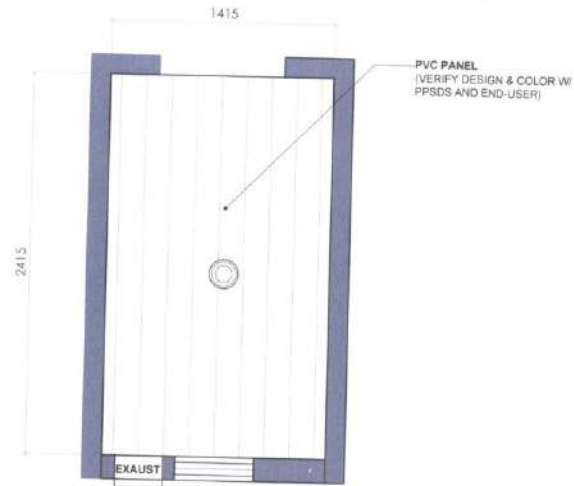

1 REFLECTED CEILING PLAN
SCALE: 1:30

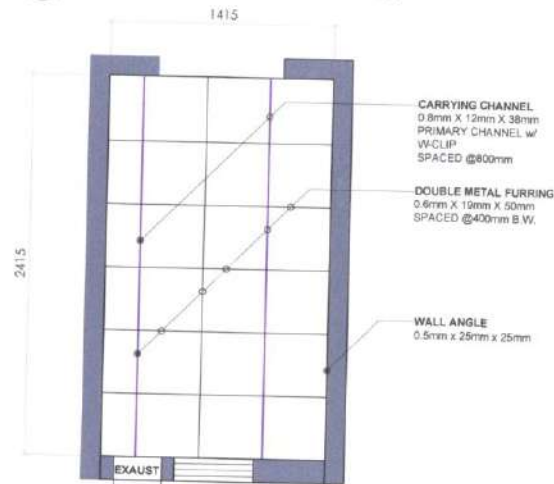

2 CEILING FRAMING PLAN
SCALE: 1:30

REGISTRAR'S OFFICE CR

G R O U N D F L O O R

DOOR TYPE: PVC FLUSH DOOR W/ LOUVERS	WINDOW TYPE: 3/4" THK TINTED GLASS & ALUMINUM FRAME AWNING WINDOW
DOOR SIZE (w x h): 800mm x 2100mm	WINDOW SIZE (w x h): 400mm x 500mm
NO. OF DOOR/S: 1 PC	REQ'D NO. OF WINDOWS: 1 SET
LOCATION: REGISTRAR'S OFFICE CR	LOCATION: REGISTRAR'S OFFICE CR

3 SCHEDULE OF DOORS & WINDOWS (A)
SCALE: 1:30

SIGNED AND SEALED BY:

PROJECT AND LOCATION:

PREPARED BY:

SUBMITTED BY:

CONCURRED BY:

RECOMMENDING APPROVAL:

APPROVED BY:

SHEET NO:

PRC REG NO. _____ VALID UNTIL: _____
PTR NO. _____ VALID UNTIL: _____
PLACE OF ISSUE: _____ DATE ISSUE: _____
TIN NO. _____



REPAIR/IMPROVEMENT OF COMFORT ROOMS
NUEVA VIZCAYA STATE UNIVERSITY
BAMBANG CAMPUS

DENNIS R. O. VALDEZ
Architect

JENNIE ROSE J. MORANTE
Architect

OFELIA S. RUBIO
Director, PPSDS
JYRUS V. CASADIENTE
Director, PPSDS

GERALDO L. PEREZ
Campus Administrator


CARLO F. VADIL
VP for Planning, Development and Information System

WILFREDO A. DUMALE, JR.
University President


A 6
24

REGISTRAR'S OFFICE CR


G R O U N D F L O O R

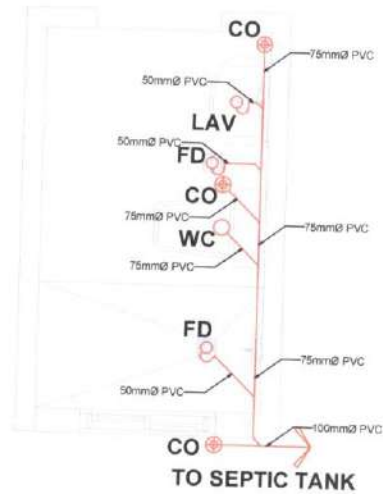


1 SANITARY LINE LAYOUT
SCALE: 1:30

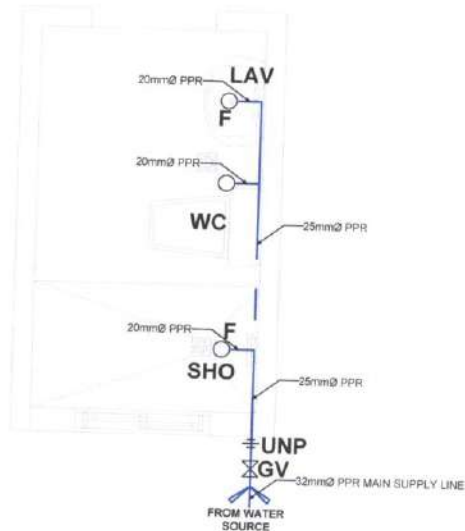

2 WATER LINE LAYOUT
SCALE: 1:30

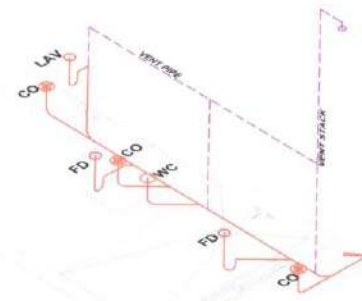

3 SANITARY LINE ISOMETRIC LAYOUT
SCALE: 1:30

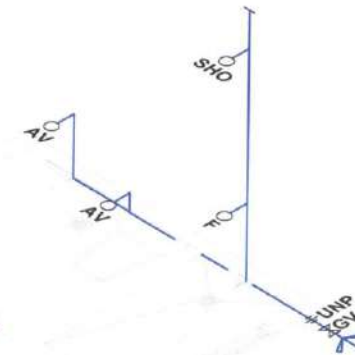

4 WATER LINE ISOMETRIC LAYOUT
SCALE: 1:30

LEGEND

SYMBOL	DESCRIPTION	SYMBOL	DESCRIPTION
	PIPE OUTLET/FAUCET	F	FAUCET
	UNION PATENTE	SHO	SHOWER
	GATE VALVE	KS	KITCHEN SINK
	WATER LINE	LAV	LAVATORY
	FLOOR TRAP	WC	WATER CLOSET
	PIPE OUTLET/FAUCET	YS	VENT STACK
	CLEAN-OUT W/ COCK	UNP	UNION PATENTE
	BLACK WATER/WHITE WATER	GV	GATE VALVE
	VENT PIPE	SS	STOP SINK
	AIR VALVE	SP	STACK PIPE
	URINAL	RP	RISER PIPE

SIGNED AND SEALED BY:

PROJECT AND LOCATION:

PREPARED BY:

SUBMITTED BY:

CONCURRED BY:

RECOMMENDING APPROVAL:

APPROVED BY:

SHEET NO:

PROJ. REG. NO. _____ VALID UNTIL: _____
PTR. NO. _____ VALID UNTIL: _____
PLACE OF ISSUE: _____ DATE ISSUE: _____
TIN NO. _____



**REPAIR/IMPROVEMENT OF
COMFORT ROOMS**
NUEVA VIZCAYA STATE UNIVERSITY,
DABAWAN CAMPUS

JOSEPH NEL S. RUBIO
Architect/Engineer

OFELIA S. RUBIO
Director, PPDOS
JYRUS JYLES CADIENTE
Director, PPDOS

GERALDO L. PEREZ
Campus Administrator


CARLO F. VADIL
VP for Planning, Development and Information System

WILFREDO A. DUMALE, JR.
University President


P 1
16

BUDGET OFFICE (NEW CR)


G R O U N D F L O O R

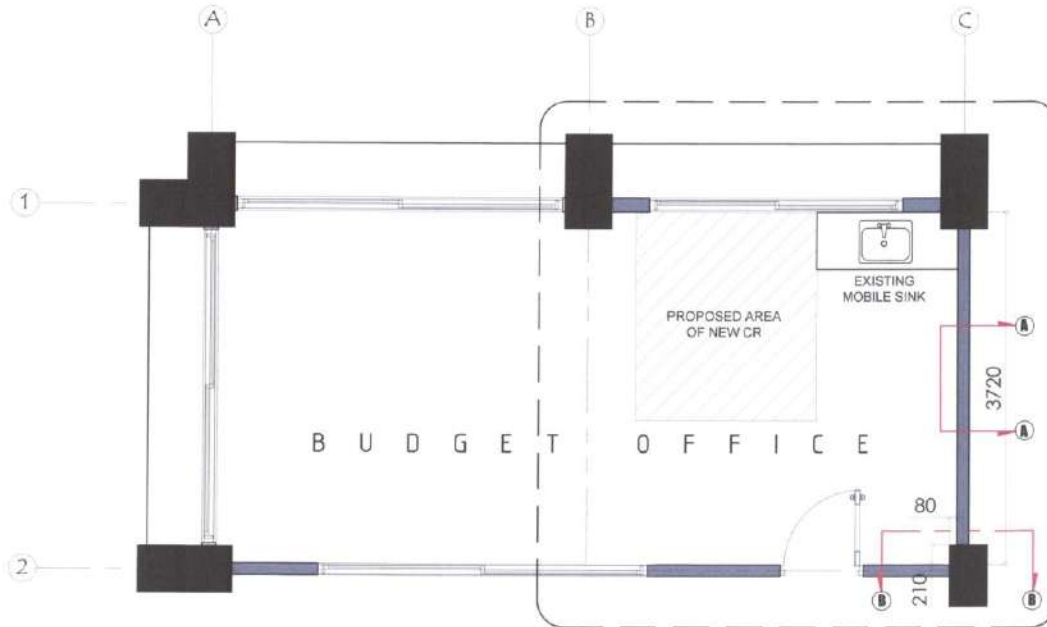

1 AS-BUILT PLAN
SCALE: 1:50

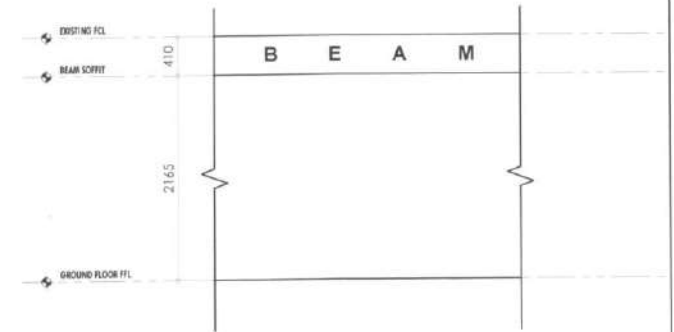

2 SECTION A
SCALE: 1:50

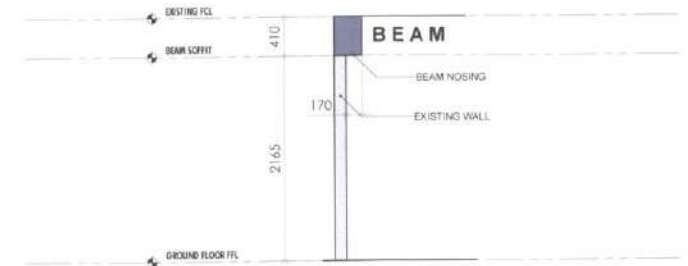

3 SECTION B
SCALE: 1:50




ACTUAL SITE



SIGNED AND SEALED BY:	PROJECT AND LOCATION:	PREPARED BY:	SUBMITTED BY:	CONCURRED BY:	RECOMMENDING APPROVAL:	APPROVED BY:	SHEET NO:
PRC REG NO: _____ VALID UNTIL: _____ PTR NO: _____ VALID UNTIL: _____ PLACE OF ISSUE: _____ DATE ISSUE: _____ TIN NO: _____	 REPAIR/ IMPROVEMENT OF COMFORT ROOMS NUEVA VIZCAYA STATE UNIVERSITY, BAMBANG CAMPUS	 DENNIS RIO E. VALDEZ Architect  JENNIE ROSE J. MORANTE Architect	 JYRUS JYLES CADIENTE Director PPSOS	 OFELIA S. RUSIO Director PPSOS  GERALD L. PEREZ Campus Administrator	 CARLO F. VADIL VP for Planning and Information System	 WILFREDO A. DUMALE, JR University President	

BUDGET OFFICE (NEW CR)

G R O U N D F L O O R

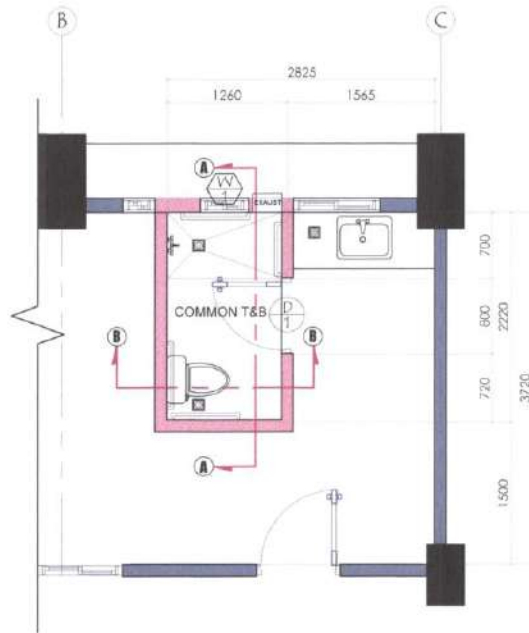

1 PROPOSED PLAN
SCALE: 1:60

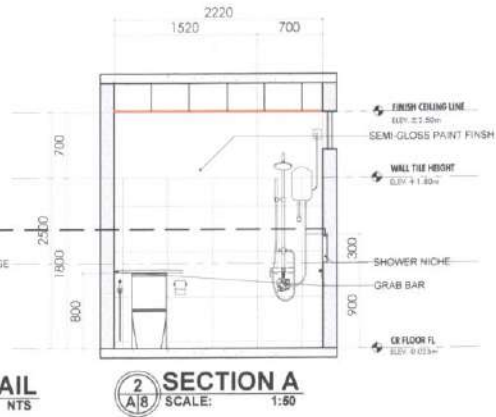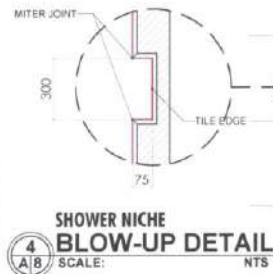

VISUALIZATION

SIGNED AND SEALED BY:

PROJECT AND LOCATION:

PREPARED BY:

SUBMITTED BY:

CONCURRED BY:

RECOMMENDING APPROVAL:

APPROVED BY:

SHEET NO:

PRC REG NO. _____
PTR NO. _____
PLACE OF ISSUE _____
DATE OF ISSUE _____
TIN NO. _____



**REPAIR/ IMPROVEMENT OF
COMFORT ROOMS**
NUEVA VIZCAYA STATE UNIVERSITY,
BAMBANG CAMPUS

Dennis R. Valdez
DENNIS R. VALDEZ
Architect

Jennie Rose J. Morante
JENNIE ROSE J. MORANTE
Architect

Ofelia S. Rubio
OFELIA S. RUBIO
JYRUS JYLES CADIENTE
Director, PPSDS

Gerald L. Perez
GERALD L. PEREZ
Services Administrator


Carl F. Vadil
CARL F. VADIL
VP for Planning, Development and Information Systems

Wilfredo A. Dumale, Jr.
WILFREDO A. DUMALE, JR.
University President

A 8
24

BUDGET OFFICE (NEW CR)

G R O U N D F L O O R

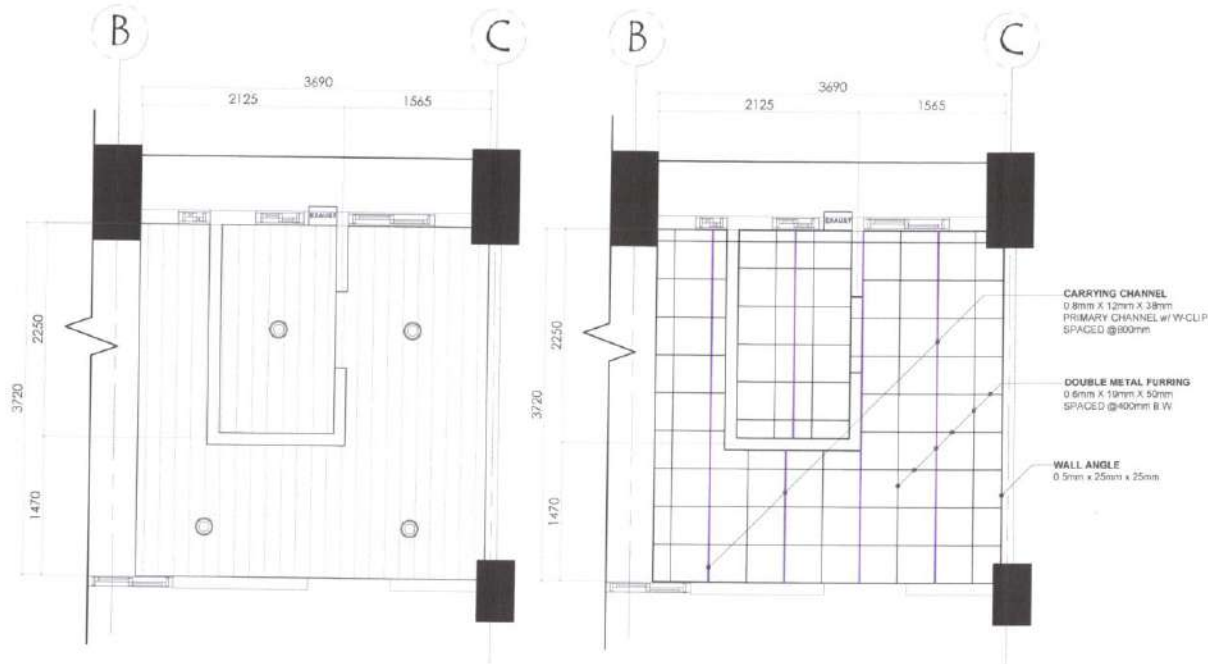


DOOR TYPE: PVC FLUSH DOOR W/ LOUVERS	WINDOW TYPE: 1/2" THK TINTED GLASS & ALUMINUM FRAME AWNING WINDOW
DOOR SIZE (H x W): 2100mm x 800mm	WINDOW SIZE (H x W): 1900mm x 500mm
NO. OF DOORS: 1 PC	REQ'D NO. OF WINDOWS: 1 SET
LOCATION: G.FLR BUDGET OFFICE	LOCATION: G.FLR BUDGET OFFICE

3 SCHEDULE OF DOORS & WINDOWS (B)
SCALE: 1:50


SIGNED AND SEALED BY:	PROJECT AND LOCATION:	PREPARED BY:	SUBMITTED BY:	CONCURRED BY:	RECOMMENDING APPROVAL:	APPROVED BY:	SHEET NO:
PRC REG NO. _____ VALID UNTIL _____ PTR NO. _____ VALID UNTIL _____ PLACE OF ISSUE _____ DATE ISSUE _____ TRV NO. _____	 REPAIR/ IMPROVEMENT OF COMFORT ROOMS NUEVA VIZCAYA STATE UNIVERSITY, BAMBANG CAMPUS	 DENNIS RIO C. VALDEZ Architect  JENNIE ROSE J. MORANTE Architect	 JYRUS JYLES CADIENTE Director, PRSDS	 GERALD L. PEREZ Campus Administrator	 CARLO F. VADIL VP for Planning, Development and Information Systems	 WALFREDO A. DUMALE, JR University President	

BUDGET OFFICE (NEW CR)





G R O U N D F L O O R

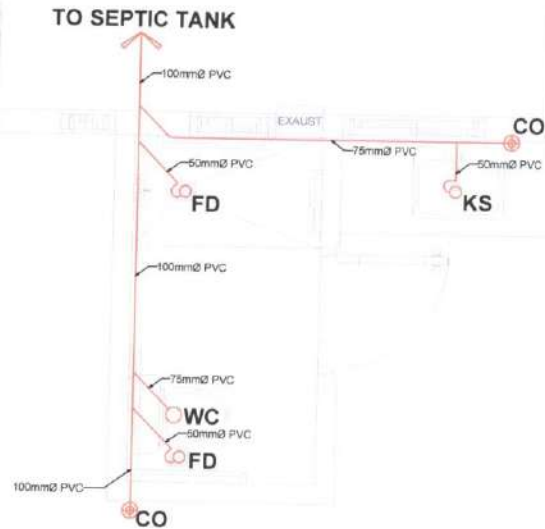

1 SANITARY LINE LAYOUT
SCALE: 1:30

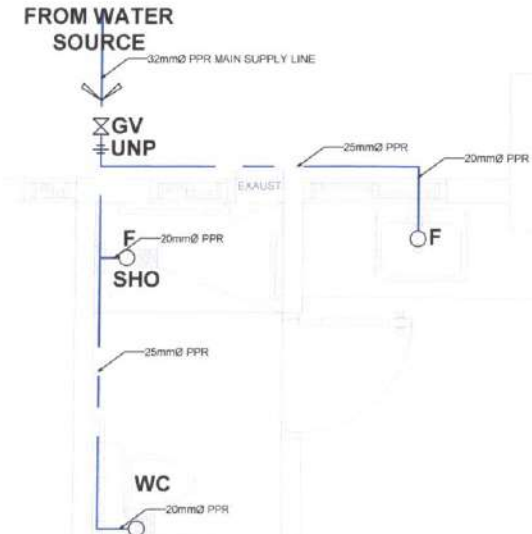


2 WATER LINE LAYOUT
SCALE: 1:30

    
SIGNED AND SEALED BY:	PROJECT AND LOCATION:	PREPARED BY:	SUBMITTED BY:	CONCURRED BY:	RECOMMENDING APPROVAL:	APPROVED BY:	SHEET NO:
PRC REG NO. _____ PTR NO. _____ PLACE OF ISSUE _____ TIN NO. _____	 REPAIR/IMPROVEMENT OF COMFORT ROOMS NUEVA VIZCAYA STATE UNIVERSITY, BAMBANG CAMPUS	 JOSEPH NEIL S. RUBIO NTHMAGI Master Plumber	 JYRUS JULES CADIENTE Director, PPSOS	 GERALD L. PEREZ Campus Administrator	 CARLO F. VADIL VP for Planning, Development and Information System	 WILFREDO A. DUMALE, JR. University President	

BUDGET OFFICE (NEW CR)

G R O U N D F L O O R

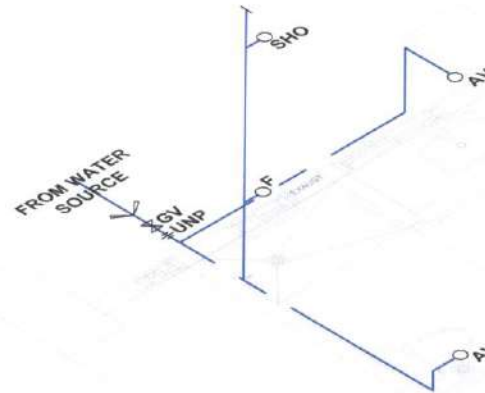

2 WATER LINE ISOMETRIC LAYOUT
SCALE: 1:30

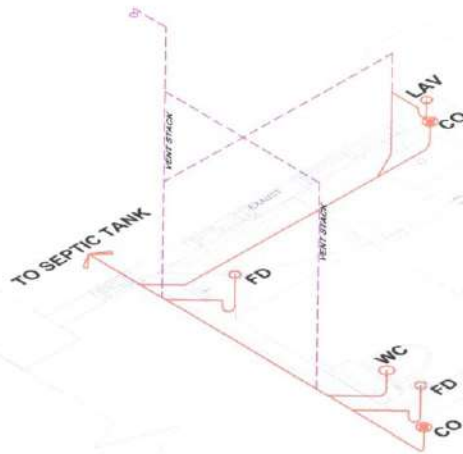

1 SANITARY LINE ISOMETRIC LAYOUT
SCALE: 1:30

LEGEND

SYMBOL	DESCRIPTION	SYMBOL	DESCRIPTION
	PIPE	F	FAUCET
	UNION / PATENT	SHO	SHOWER
	GATE VALVE	KS	KITCHEN SINK
	WATER LINE	LAV	LAVATORY
	P-TRAP	WC	WATER CLOSET
	PIPE OUTLET/VALVE	VS	VENT STACK
	CLEAN-OUT W/ COVER	UNP	UNION / PATENT
	WASH/WASTE/WATER LINE	GV	GATE VALVE
	VENT PIPE	SS	SLOP-SINK
AV	ANGLE VALVE	SP	STACK PIPE
UR	URINAL	RP	RISER PIPE

SIGNED AND SEALED BY:

PROJECT AND LOCATION:

PREPARED BY:

SUBMITTED BY:

CONCURRED BY:

RECOMMENDING APPROVAL:

APPROVED BY:

SHEET NO:

PRG REG NO. _____ VALID UNTIL _____
PTR NO. _____ DATE ISSUE _____
PLACE OF ISSUE _____
TRF NO. _____



**REPAIR/IMPROVEMENT OF
COMFORT ROOMS**
NUEVA VIZCAYA STATE UNIVERSITY,
BAMBANG CAMPUS

JOSEPH NEIL S. RUBIO
Analyst Under Process

OFELIA S. RUBIO
Chief, Planning
JYRUS JYLES CADIENTE
Director, PPSCS

GERALD L. PEREZ
Campus Administrator


GAR O F. PADIL
VP for Planning Development and Information Systems

WILFREDO A. DUMALE, JR.
University President

P 3
16

MEN & LADIES' COMMON CR

G R O U N D F L O O R

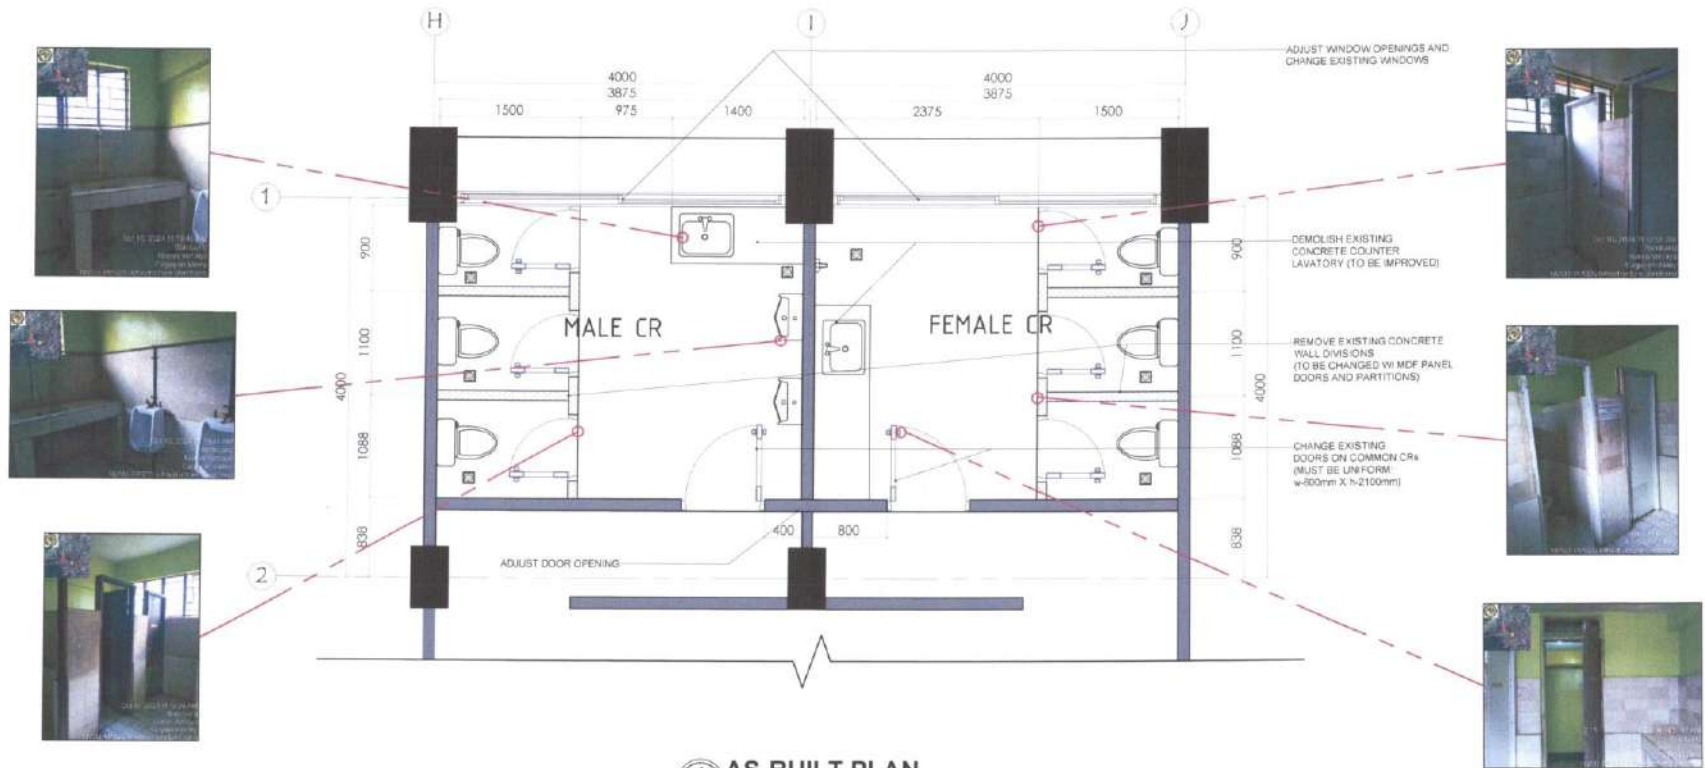

1 AS-BUILT PLAN
A10 SCALE: 1:80

ACTUAL SITE


ACTUAL SITE

SIGNED AND SEALED BY:	PROJECT AND LOCATION:	PREPARED BY:	SUBMITTED BY:	CONCURRED BY:	RECOMMENDING APPROVAL:	APPROVED BY:	SHEET NO:
PRC REG NO. _____ VALID UNTIL _____ PTR. NO. _____ VALID UNTIL _____ PLACE OF ISSUE _____ DATE OF ISSUE _____ TIN NO. _____	 REPAIR/ IMPROVEMENT OF COMFORT ROOMS NUEVA VIZCAYA STATE UNIVERSITY, BAMBANG CAMPUS	 DENNIS RIO C. VALDEZ Architect  JENNIE ROSE J. MORANTE Architect	 OPHELIA S. RUBIO Office Staff  JYRUS VILES CADIENTE Director PRCOS	 GERALD L. PEREZ Campus Administrator	 CARLO F. YABIL VP for Planning, Development and Information Systems	 WILFREDO A. DUMALE, JR University President	A10 24


MEN'S COMMON CR GROUND FLOOR




VISUALIZATION

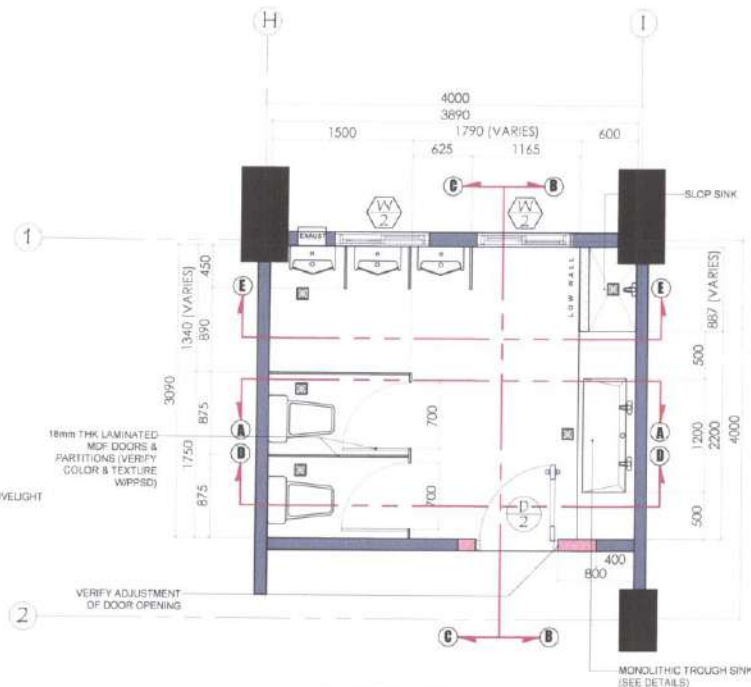

1 PROPOSED PLAN
SCALE: 1:50

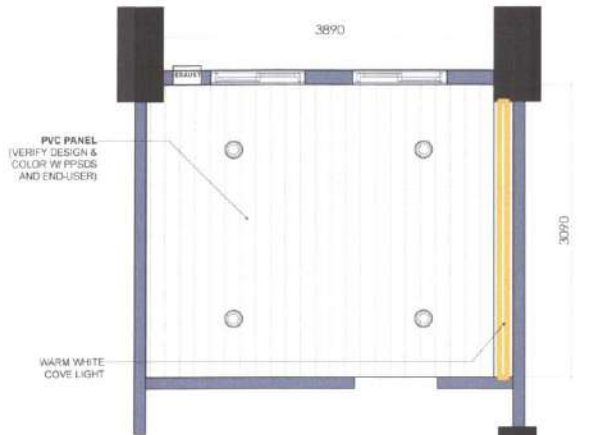

2 REFLECTED CEILING PLAN
SCALE: 1:50

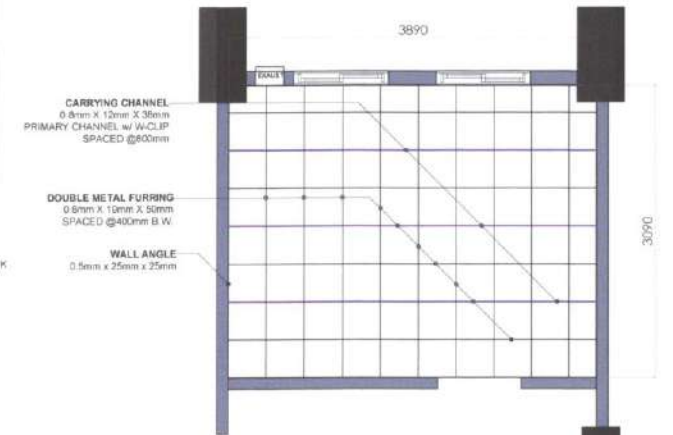


3 CEILING FRAMING PLAN
SCALE: 1:50


SIGNED AND SEALED BY:	PROJECT AND LOCATION:	PREPARED BY:	SUBMITTED BY:	CONCURRED BY:	RECOMMENDING APPROVAL:	APPROVED BY:	SHEET NO:
ARC. REG. NO. _____ PTR. NO. _____ PLACE OF ISSUE _____ T.N. NO. _____ VALID UNTIL _____ VALID UNTIL _____ DATE ISSUE _____	 REPAIR/ IMPROVEMENT OF COMFORT ROOMS NUEVA VIZCAYA STATE UNIVERSITY, BAMBANG CAMPUS	 DENNIS RICAL VALDEZ Architect  JENNIE ROSE J. MORANTE Architect	 JYRUS M. CADIENTE Director, PPGSOS	 GERARDO L. PEREZ Campus Administrator	 CARLO F. ADIL Vir for Planning, Development and Information System	 WILFREDO A. BUNALE, JR. University President	

MEN'S COMMON CR


GROUND FLOOR

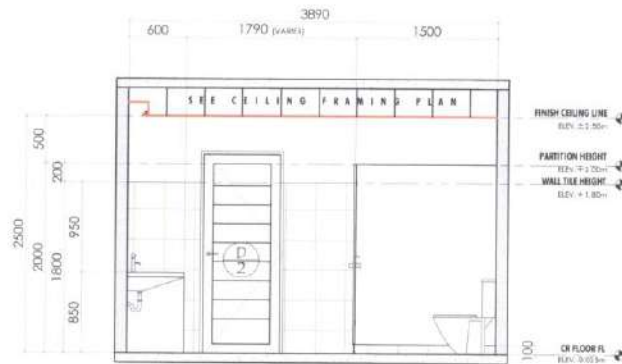


1 SECTION A
SCALE: 1:50

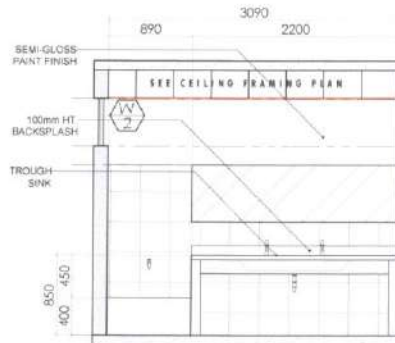


2 SECTION B
SCALE: 1:50

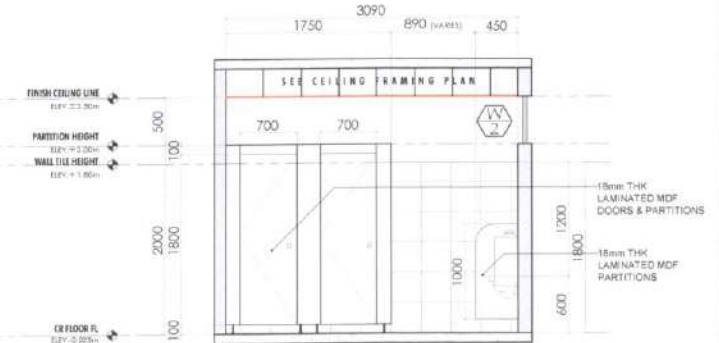

3 SECTION C
SCALE: 1:50

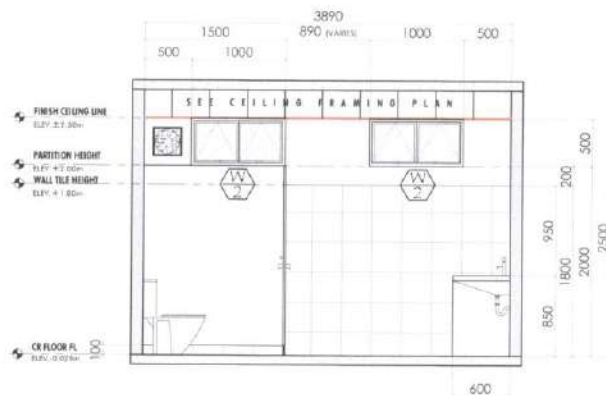

4 SECTION D
SCALE: 1:50


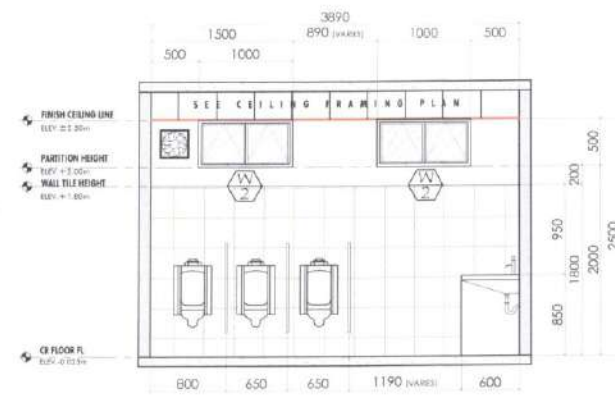






5 SECTION E
SCALE: 1:50

SIGNED AND SEALED BY:	PROJECT AND LOCATION:	PREPARED BY:	SUBMITTED BY:	CONCURRED BY:	RECOMMENDING APPROVAL:	APPROVED BY:	SHEET NO:
PRC REG NO. _____ VALID UNTIL _____ PPRND _____ VALID UNTIL _____ PLACE OF ISSUE: _____ DATE ISSUE: _____ TRIND _____	 REPAIR/ IMPROVEMENT OF COMFORT ROOMS NUEVA VIZCAYA STATE UNIVERSITY, BAMBANG CAMPUS	 DENNIS RIO C. VALDEZ Architect	 JENNIE ROSE J. MORANTE Architect	 JYRUS JYLES CADIENTE Director PPGOS	 GERALD L. PEREZ Campus Administrator	 CARLO F. VADIL VP for Planning, Development and Information System	 WILFREDO A. DUMALE, JR. University President
							A12 24

MEN'S COMMON CR

    
GROUND FLOOR

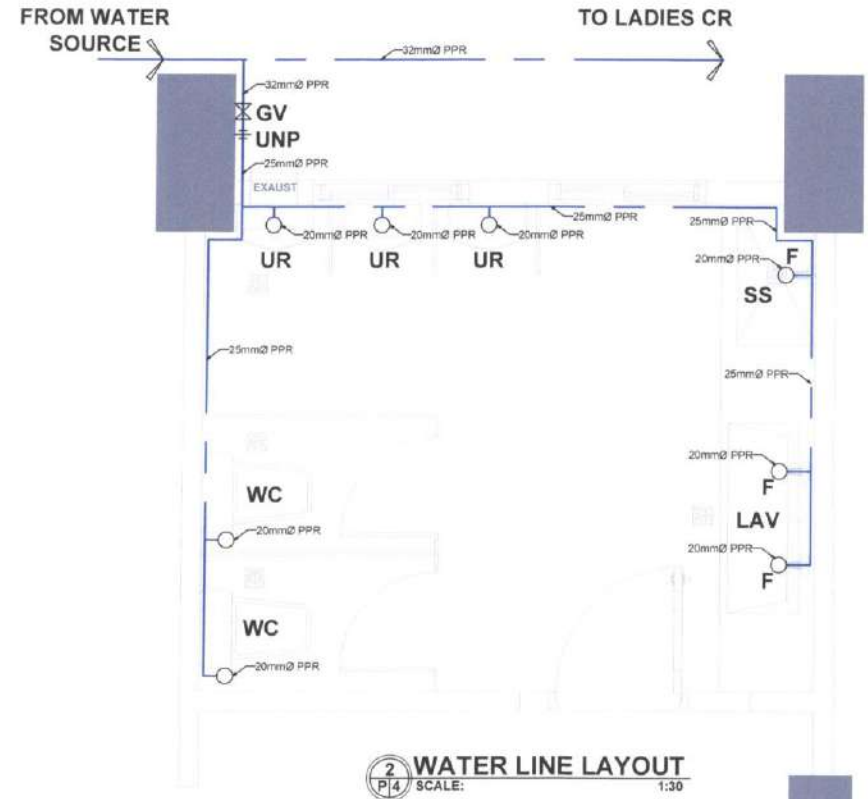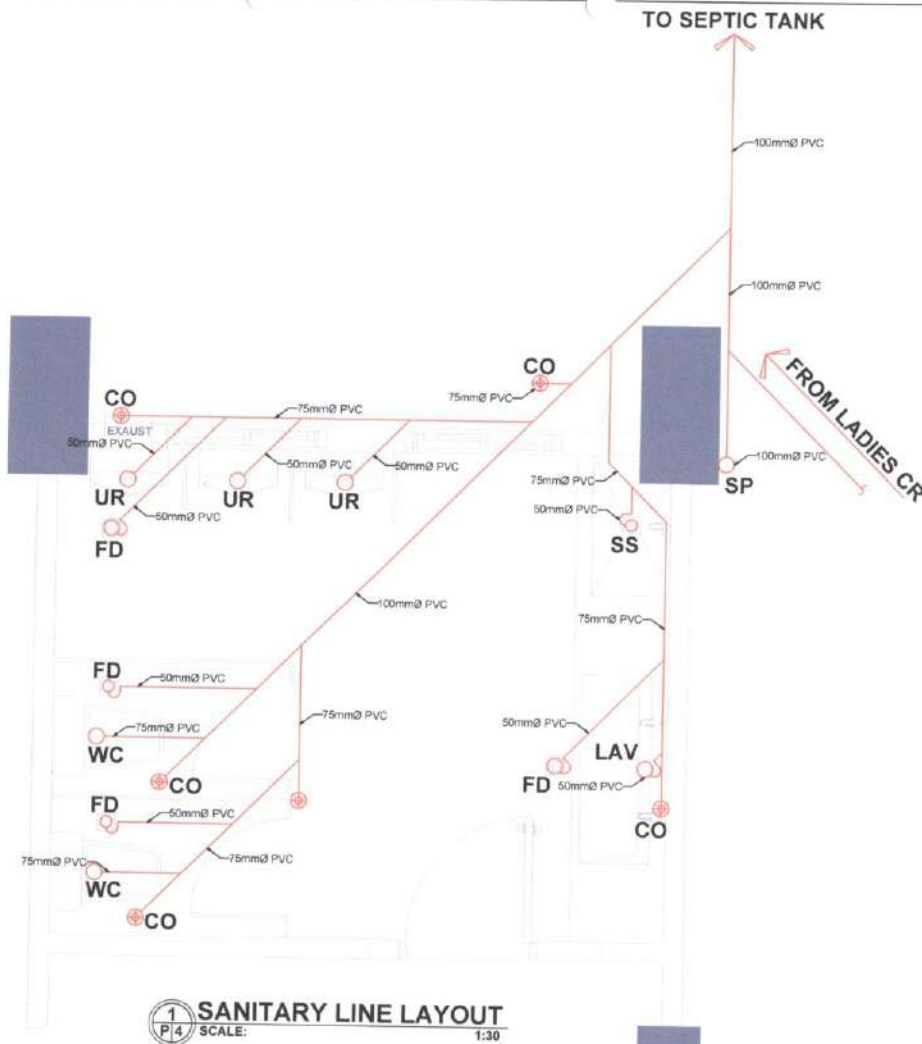

SIGNED AND SEALED BY:	PROJECT AND LOCATION:	PREPARED BY:	SUBMITTED BY:	CONCURRED BY:	RECOMMENDING APPROVAL:	APPROVED BY:	SHEET NO:
PRC REG NO: _____ VALID UNTIL: _____ PTR NO: _____ VALID UNTIL: _____ PLACE OF ISSUE: _____ DATE ISSUE: _____ TR NO: _____	 REPAIR/IMPROVEMENT OF COMFORT ROOMS NUEVA VIZCAYA STATE UNIVERSITY, BAMBANG CAMPUS	 JOSEPH NEW S. RUBIO ARCHITECT-Master Planner	 JYRUS JYLES CADIENTE Director, PPSOS	 GERALD L. PEREZ Campus Administrator	 CARLO F. VADIL VP for Planning, Development and Information System	 WILFREDO A. DUMALE, JR. University President	

MEN'S COMMON CR

GROUND FLOOR

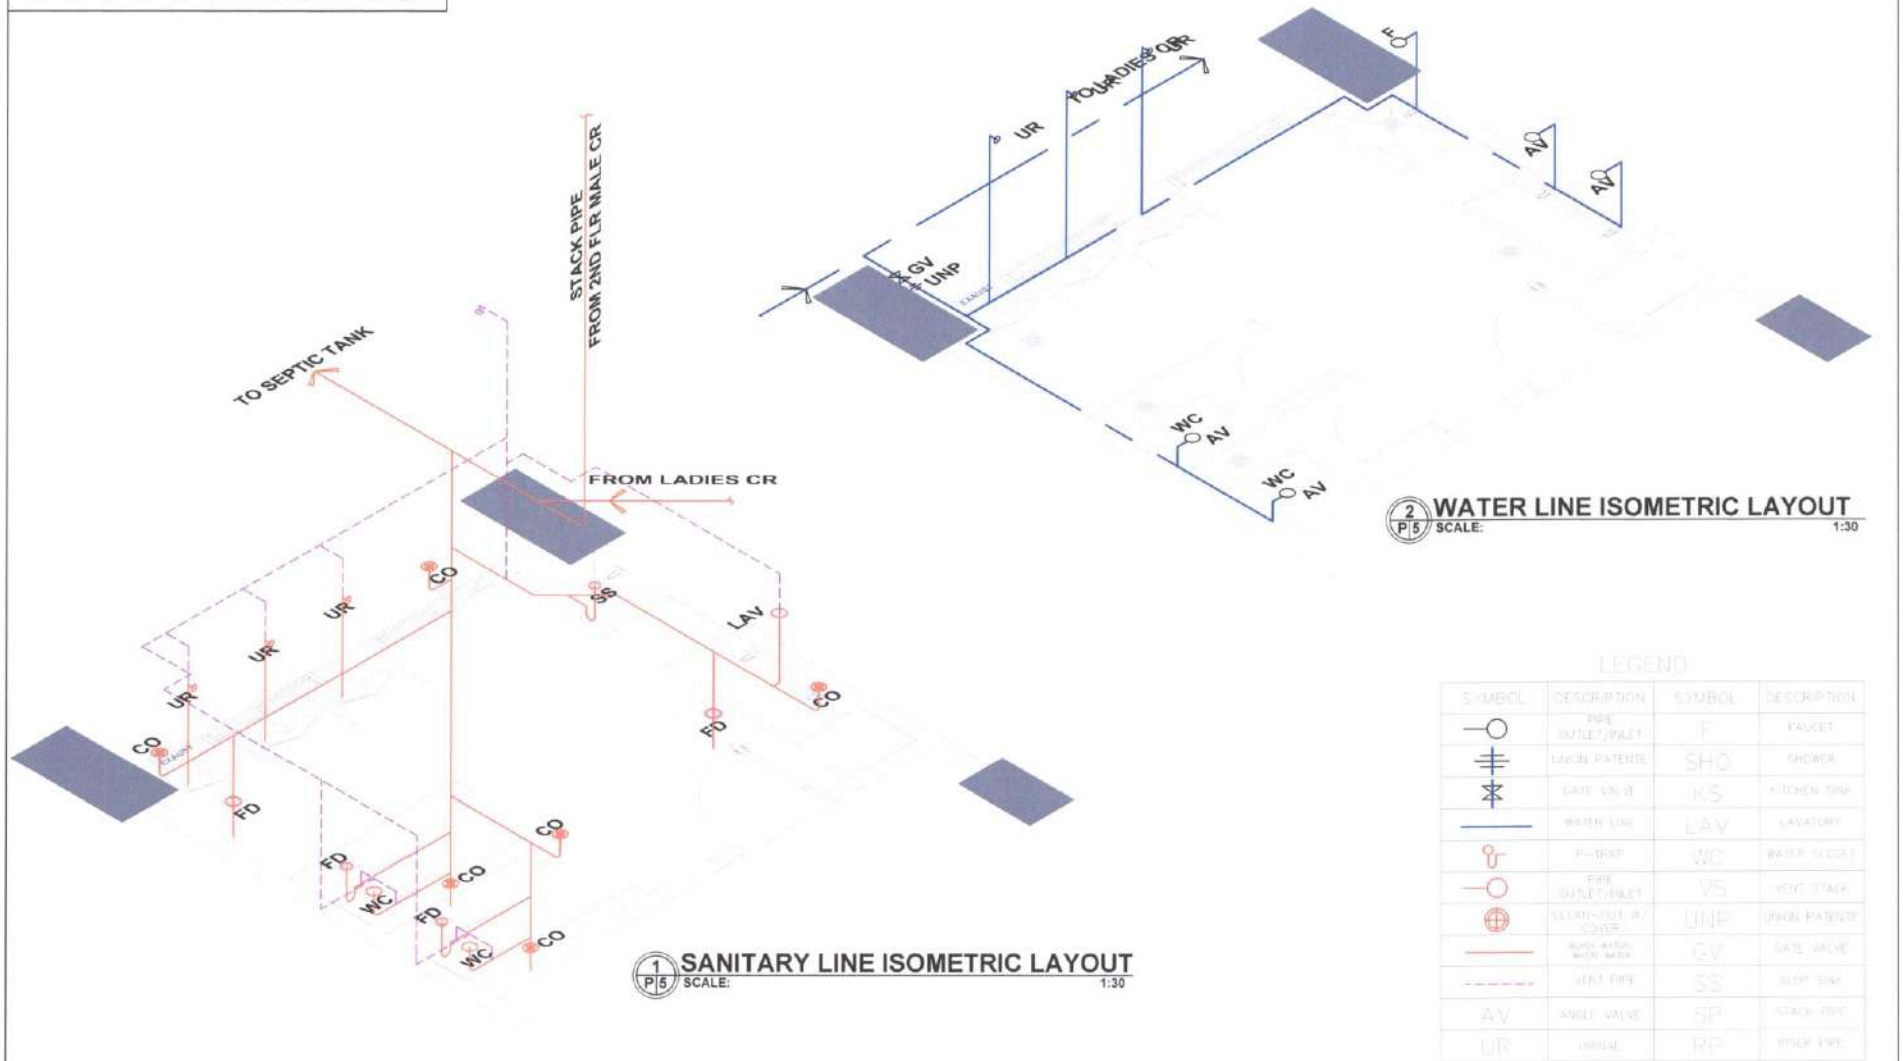

LEGEND

SYMBOL	DESCRIPTION	SYMBOL	DESCRIPTION
	PIPE OUTLET/INLET	F	FAUCET
	UNION PATENT	SHO	SHOWER
	GATE VALVE	KS	KITCHEN SINK
	WATER LINE	LAV	LAVATORY
	F-TRIP	WC	WATER CLOSET
	PIPE OUTLET/INLET	VS	VENT STACK
	CLEAN-OUT W/ COUPLER	UNP	UNION PATENT
	STACK PIPE	GV	GATE VALVE
	VENT PIPE	SS	STACK PIPE
	ANGLE VALVE	SP	STACK PIPE
	URINAL	RP	ROOF PIPE

SIGNED AND SEALED BY:

PROJECT AND LOCATION:

PREPARED BY:

SUBMITTED BY:

CONCURRED BY:

RECOMMENDING APPROVAL:

APPROVED BY:

SHEET NO:

PRC REG NO: _____ VALID UNTIL: _____
PTR NO: _____ VALID UNTIL: _____
PLACE OF ISSUE: _____ DATE ISSUE: _____
TRN NO: _____



**REPAIR/IMPROVEMENT OF
COMFORT ROOMS**
NUEVA VIZCAYA STATE UNIVERSITY,
BAMBANG CAMPUS

JOSEPH NEIL S. RUBIO
Architect Master Planner

JYRUS VILES CADIENTE
Director, PPSPD

GERALD L. PEREZ
Campus Administrator

CARLO F. VADIL
VP for Planning Development and Information Systems



WILFREDO A. DUMALE, JR
University President

**P 5
16**

LADIES' COMMON CR GROUND FLOOR




VISUALIZATION

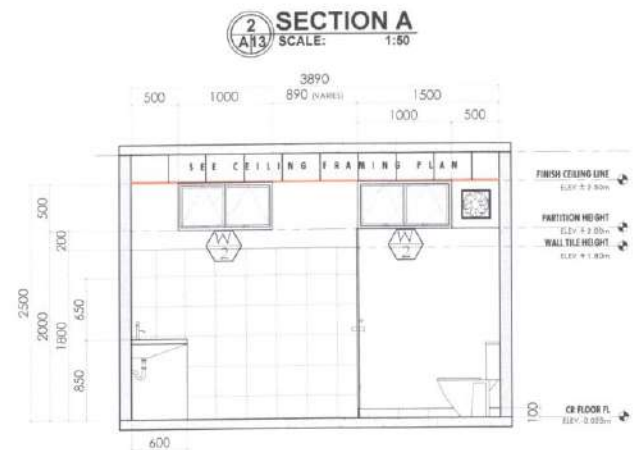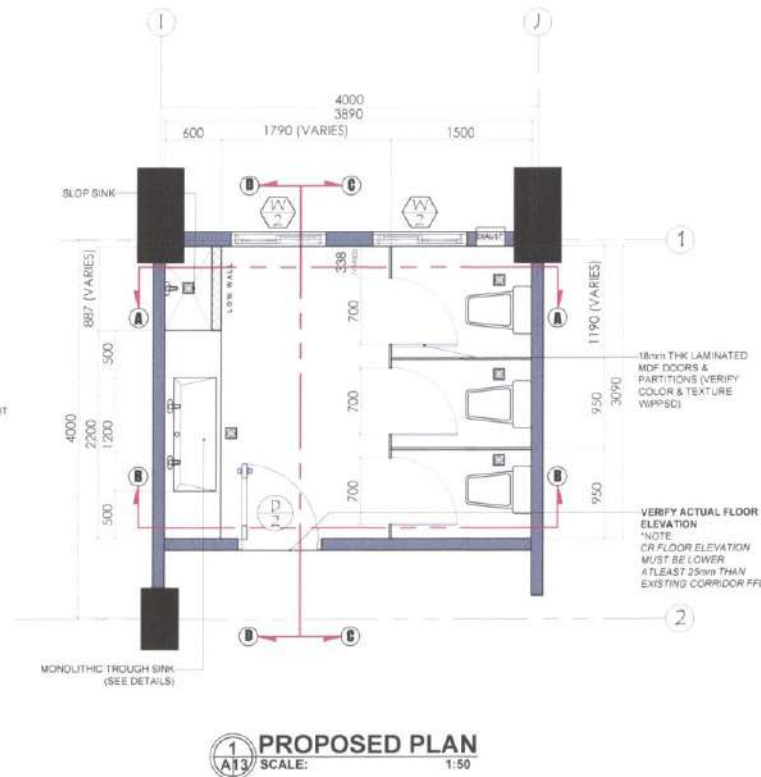


SIGNED AND SEALED BY:	PROJECT AND LOCATION:	PREPARED BY:	SUBMITTED BY:	CONCURRED BY:	RECOMMENDING APPROVAL:	APPROVED BY:	SHEET NO:	
PRC REG NO: _____ PTR NO: _____ PLACE OF ISSUE: _____ DATE OF ISSUE: _____ TIN NO: _____	 REPAIR/ IMPROVEMENT OF COMFORT ROOMS NUEVA VIZCAYA STATE UNIVERSITY BAMBANG CAMPUS	 DENNIS NO C. VALDEZ Architect	 JENNIE ROSE J. MORANTE Architect	 JYRUS JYLES CADIENTE Director, PPSDO	 GERALD L. PEREZ Campus Administrator	 CARLO F. VADIL VP for Planning Development and Information System	 WILFREDO A. DUMALE, JR. University President	A13 24

LADIES' COMMON CR


GROUND FLOOR

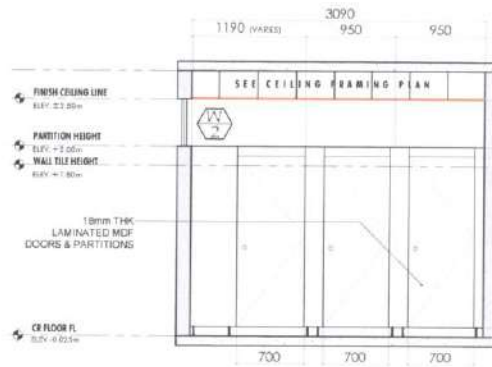


1 SECTION C
A14 SCALE: 1:50

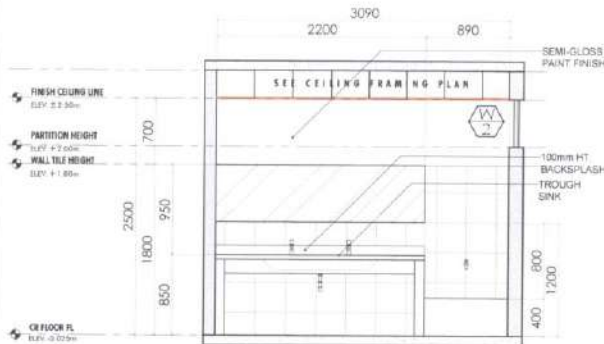


2 SECTION D
A14 SCALE: 1:50

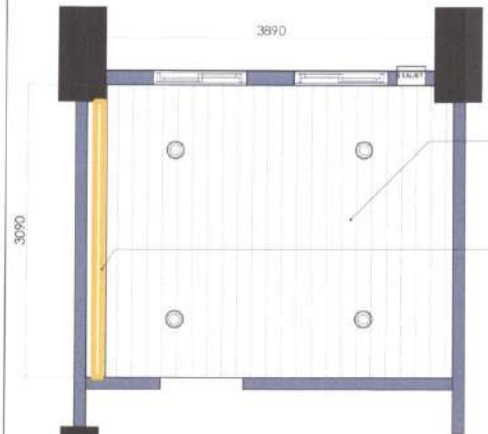


3 REFLECTED CEILING PLAN
A14 SCALE: 1:50

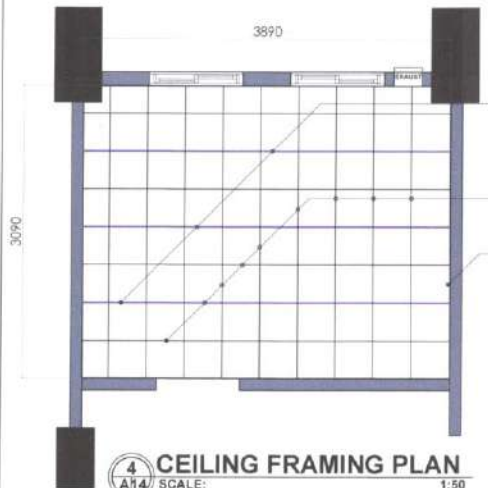

4 CEILING FRAMING PLAN
A14 SCALE: 1:50

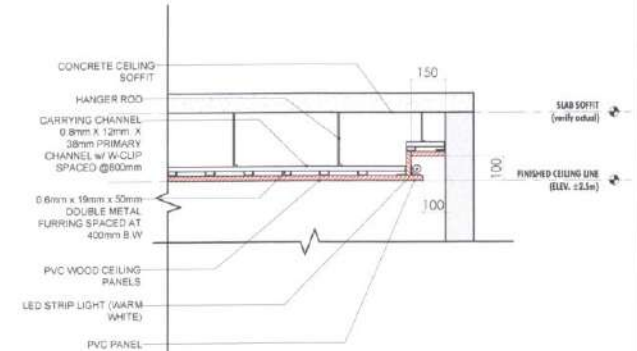



5 COVE LIGHT DETAILS
A13 SCALE: NTS

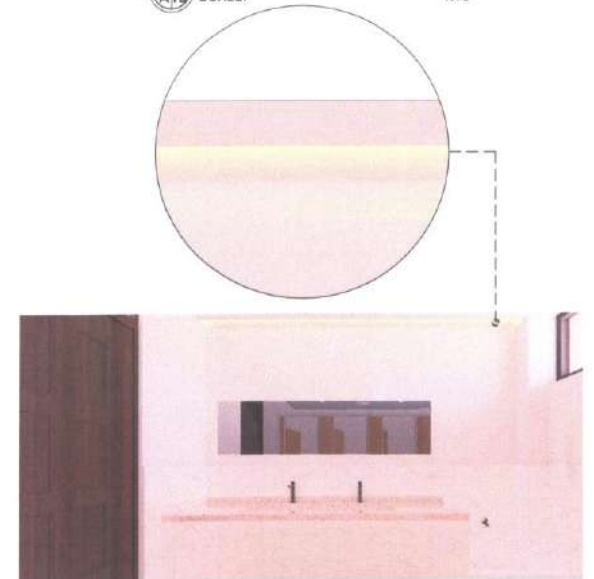

VISUALIZATION

SIGNED AND SEALED BY:	PROJECT AND LOCATION:	PREPARED BY:	SUBMITTED BY:	CONCURRED BY:	RECOMMENDING APPROVAL:	APPROVED BY:	SHEET NO:	
PRC REG NO. _____ VALID UNTIL _____ PTR NO. _____ VALID UNTIL _____ PLACE OF ISSUE _____ DATE ISSUE _____ TIN NO. _____	 REPAIR/ IMPROVEMENT OF COMFORT ROOMS NUEVA VIZCAYA STATE UNIVERSITY BAMBANG CAMPUS	 DENNIS R. C. VALDEZ Architect	 JENNIE ROSE J. MORANTE Architect	 JYRUS J. CADIANTE Director, PPSDS	 GERALD L. PEREZ Technical Administrator	 CARLO F. YADI VP for Planning, Development and Information System	 WILFREDO A. DUMALE, JR. University President	


LADIES' COMMON CR
G R O U N D F L O O R

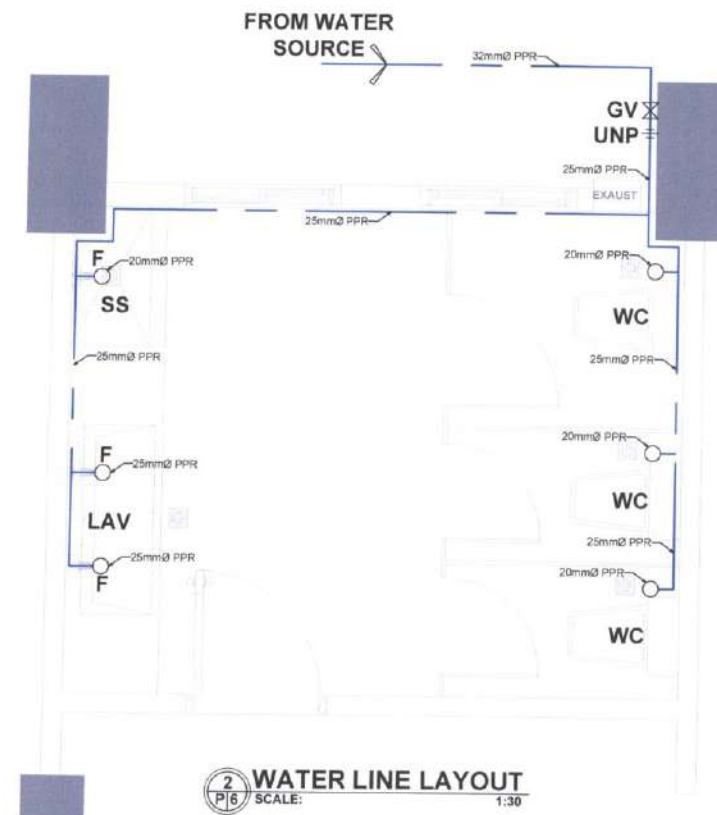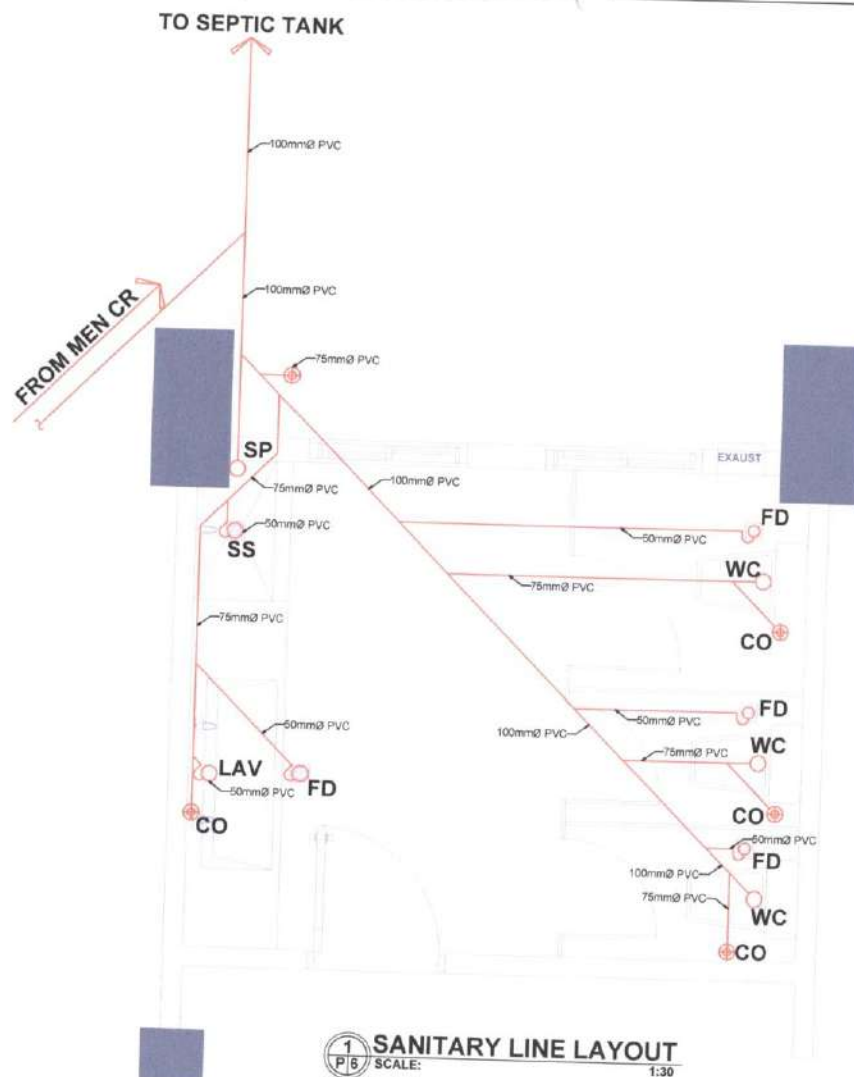


SIGNED AND SEALED BY: 		PROJECT AND LOCATION: REPAIR/IMPROVEMENT OF COMFORT ROOMS NUEVA VIZCAYA STATE UNIVERSITY, BAMBANG CAMPUS		PREPARED BY:  JOSEPH NEIL S. RUBIO Architect-Master's Number		SUBMITTED BY:  JYRUS T. CABIENTE Director, IPGDS		CONCURRED BY:  GERALD L. PEREZ Vehicle Administrator		RECOMMENDING APPROVAL:  CARLO E. ADIL VP for Planning, Management and Information System		APPROVED BY:  WILFREDO A. DUMALE, JR. University President		SHEET NO: 	
---	--	--	--	--	--	--	--	--	--	--	--	--	--	---	--

LADIES' COMMON CR

GROUND FLOOR

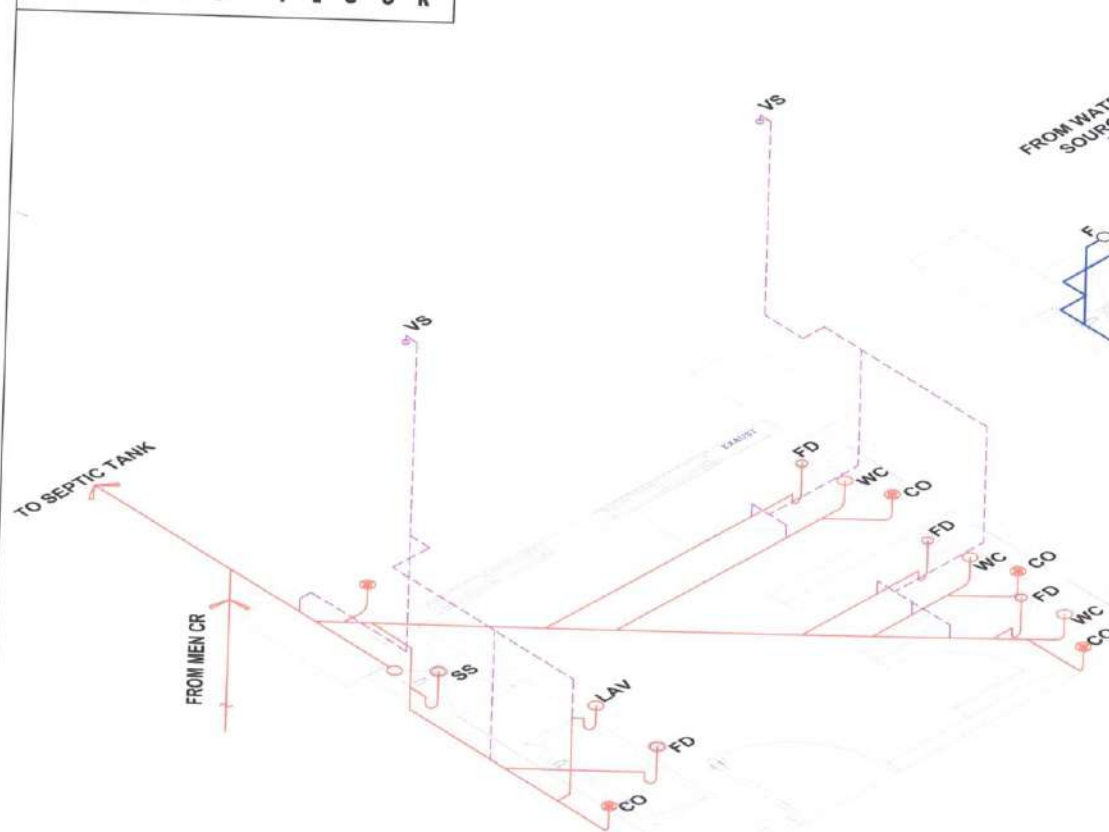

1 SANITARY LINE ISOMETRIC LAYOUT
SCALE: 1:30

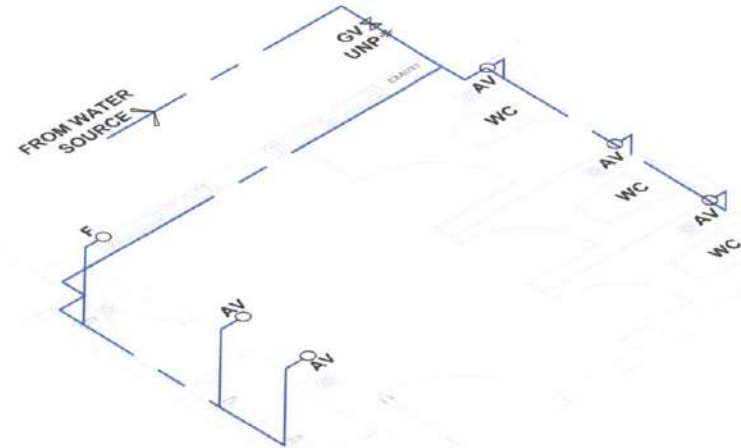

2 WATER LINE ISOMETRIC LAYOUT
SCALE: 1:30


LEGEND

SYMBOL	DESCRIPTION	SYMBOL	DESCRIPTION
	PIPE		FAUCET
	OUTLET/INLET		SHOWER
	UNION/FIXTURE		KITCHEN SINK
	GATE VALVE		LAVATORY
	WATER LINE		WC
	R-TRAP		VS
	PIPE OUTLET/INLET		UNP
	CLEAN-OUT w/ COUPLER		GV
	BLACK WATER/WASTE WATER		SS
	VENT PIPE		SP
	ANGLE VALVE		RP
	URINAL		

SIGNED AND SEALED BY:		PROJECT AND LOCATION:		PREPARED BY:		SUBMITTED BY:		CONCURRED BY:		RECOMMENDING APPROVAL:		APPROVED BY:		SHEET NO:	
PRC REG NO: _____ VALID UNTL: _____ PTR NO: _____ VALID UNTL: _____ PLACE OF ISSUE: _____ DATE ISSUE: _____ TMMO: _____		 REPAIR/IMPROVEMENT OF COMFORT ROOMS NUEVA VIZCAYA STATE UNIVERSITY, BAMBANG CAMPUS		 JOSEPH NEIL S. RUBIO ARCHITECT/MASTER PLUMBER		 OPELIA S. RUBIO CHIEF ENGINEER JYRUS JULES CADIENTE Director, PPSCD		 GERALD L. PEREZ Campus Administrator		 CARLO F. VADIL VP for Planning, Development and Information System		 WILFREDO A. DUMALE, JR. University President		 P 7 16	

TYPICAL MEN & LADIES' COMMON CR

S E C O N D F L O O R


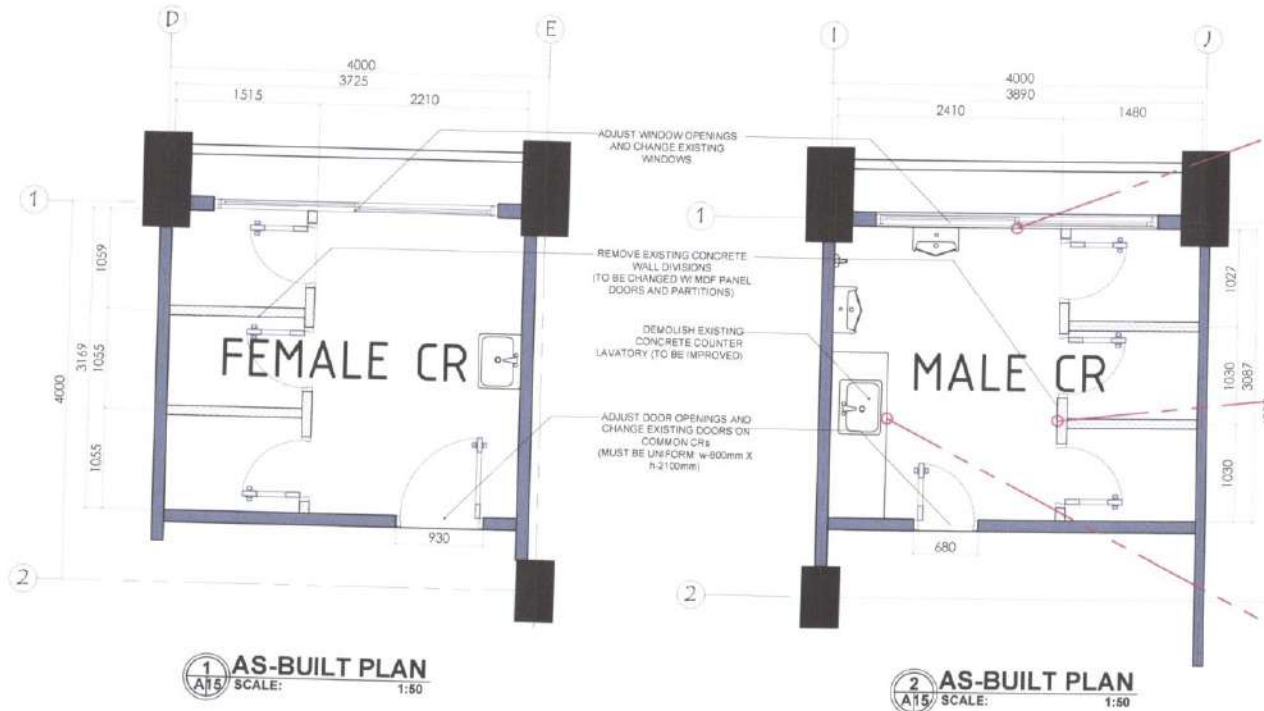


ACTUAL SITE

SIGNED AND SEALED BY:	PROJECT AND LOCATION:	PREPARED BY:	SUBMITTED BY:	CONCURRED BY:	RECOMMENDING APPROVAL:	APPROVED BY:	SHEET NO:
PRC REG NO. _____ VALID UNTIL _____ PTR NO. _____ VALID UNTIL _____ PLACE OF ISSUE _____ DATE ISSUE _____ TRN NO. _____	 REPAIR/IMPROVEMENT OF COMFORT ROOMS NUEVA VIZCAYA STATE UNIVERSITY BAMBANG CAMPUS	 DENNIS RIO E. VALDEZ OFFICE  JENNIE HOPE J. MORANTE OFFICE	 OFELIA S. RUBIO OFFICE  JYRUS VILES CADIENTE Director, PPSCS	 GERARDO L. PEREZ Campus Administrator	 CARLO F. VADIL VP for Planning, Development and Information System	 WILFREDO A. DUMALE, JR. University President	

TYPICAL MEN'S COMMON CR

S E C O N D F L O O R

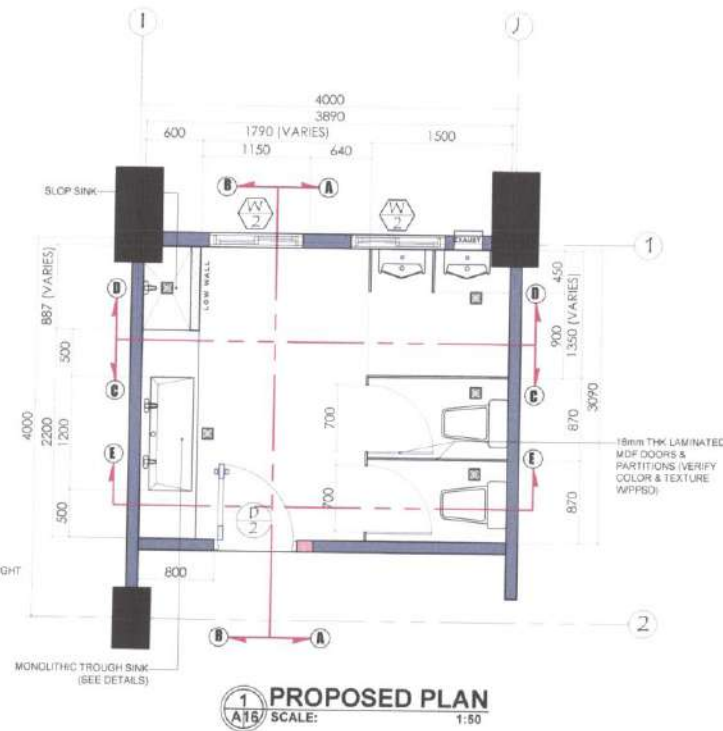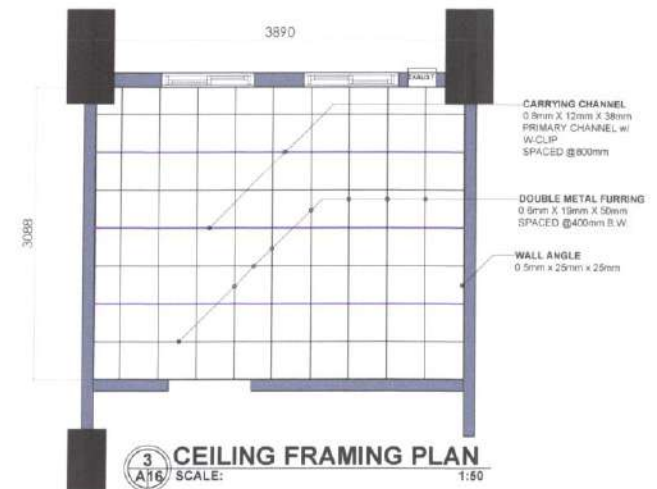


VISUALIZATION


SIGNED AND SEALED BY:	PROJECT AND LOCATION:	PREPARED BY:	SUBMITTED BY:	CONCURRED BY:	RECOMMENDING APPROVAL:	APPROVED BY:	SHEET NO:
PRC REQ NO. _____ VALID UNTIL _____ IPR NO. _____ DATE ISSUE _____ PLACE OF ISSUE: _____ TRIN NO. _____	 REPAIR/ IMPROVEMENT OF COMFORT ROOMS NUEVA VIZCAYA STATE UNIVERSITY, BAMBANG CAMPUS	 DENNIS RIO C. VALDEZ Architect  JENNIE ROSE J. MORANTE Architect	 OFELIA S. RUBIO Chief Architect  JYRUS JYLES CADIENTE Campus Administrator	 GERALD L. PEREZ Campus Administrator	 CARLO F. VADIL VP for Planning, Development and Information Systems	WILFREDO A. DUMALE, JR. University President	

TYPICAL MEN'S COMMON CR


S E C O N D F L O O R

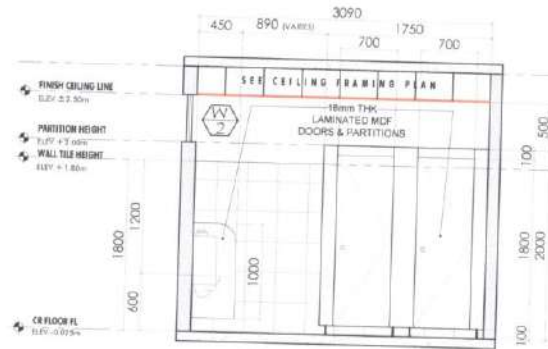


1 SECTION A
SCALE: 1:60

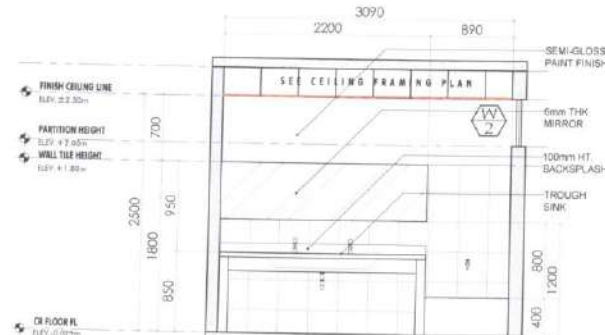


2 SECTION B
SCALE: 1:50

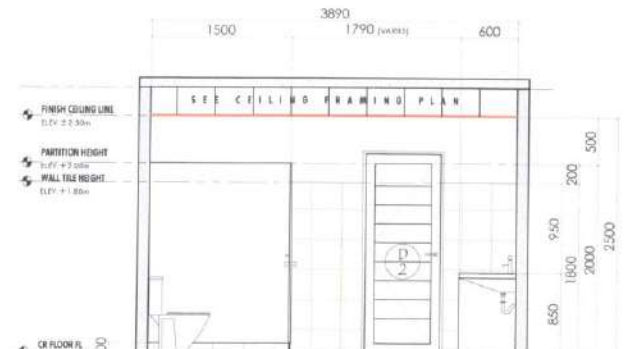

3 SECTION C
SCALE: 1:50

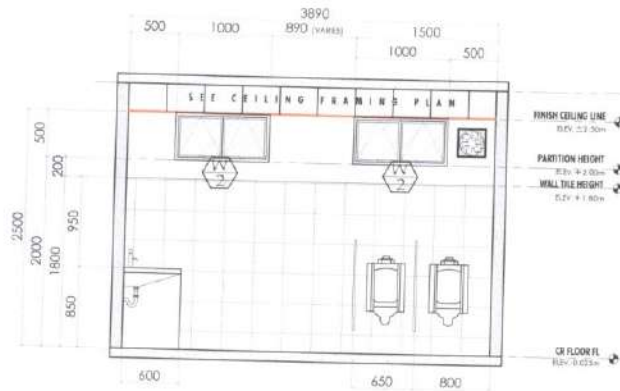

4 SECTION D
SCALE: 1:50

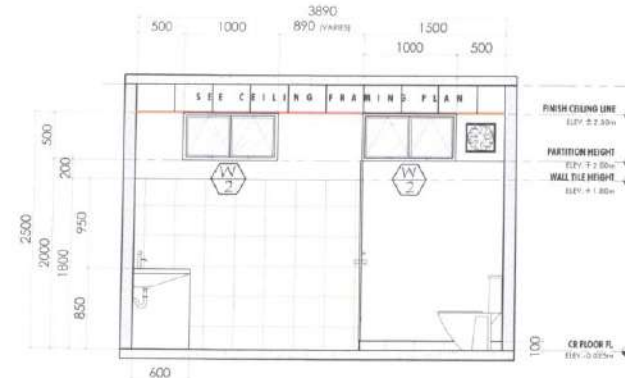


5 SECTION E
SCALE: 1:50


SIGNED AND SEALED BY:		PROJECT AND LOCATION:	PREPARED BY:	SUBMITTED BY:	CONCURRED BY:	RECOMMENDING APPROVAL:	APPROVED BY:	SHEET NO:	
PRG REG NO. _____ DTN NO. _____ VALID UNTIL _____ DATE ISSUE _____ PLACE OF ISSUE _____ TIN NO. _____		 REPAIR/IMPROVEMENT OF COMFORT ROOMS NUEVA VIZCAYA STATE UNIVERSITY BAMBANG CAMPUS	 DENNIS ROCIO VALDEZ Architect	 JENNIE ROSE J. MORANTE Architect	 JYRUS J. CADIENTE Director, PPSCD	 GERALD L. PEREZ Campus Administrator	 CARLO F. VADIL VP for Planning, Development and Information System	 WILFREDO A. DUMALE, JR. University President	

TYPICAL MEN'S COMMON CR



S E C O N D F L O O R

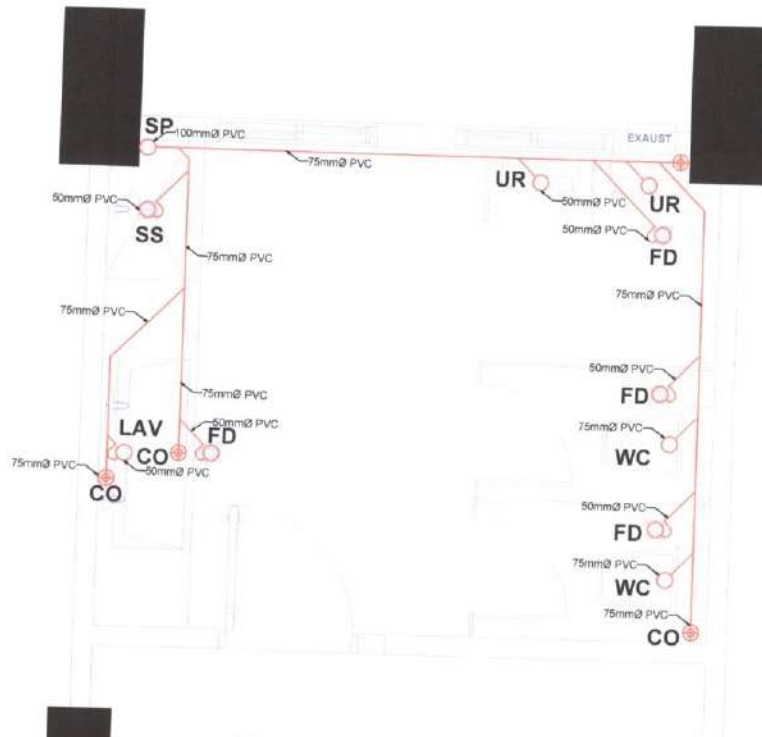

1 SANITARY LINE LAYOUT
SCALE: 1:30

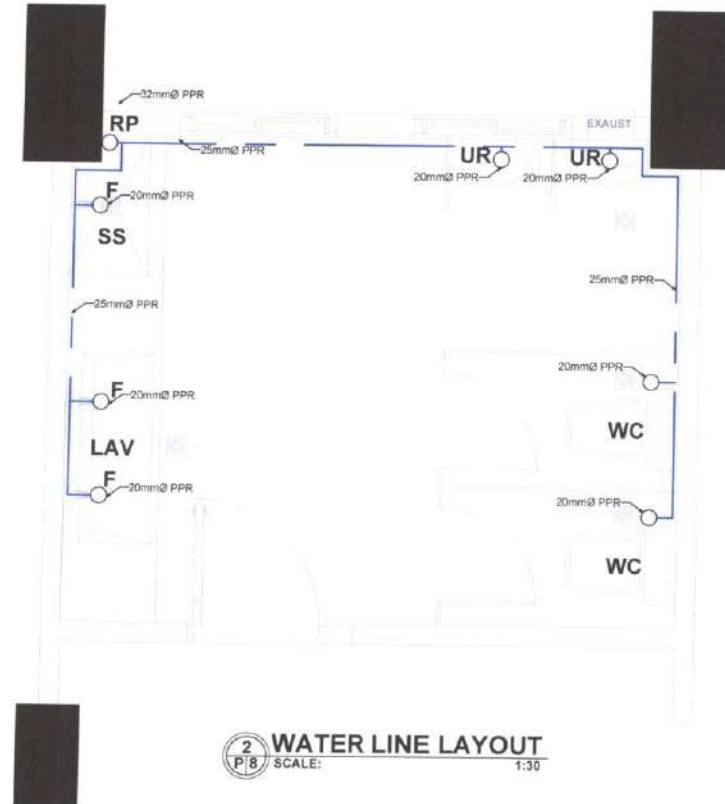


2 WATER LINE LAYOUT
SCALE: 1:30

  
SIGNED AND SEALED BY:	PROJECT AND LOCATION:	PREPARED BY:	SUBMITTED BY:	CONCURRED BY:	RECOMMENDING APPROVAL:	APPROVED BY:	SHEET NO:
PRC REG NO. _____ VALID UNTL _____ PTR NO. _____ VALID UNTL _____ PLACE OF ISSUE _____ DATE ISSUE _____ TIN NO. _____	 REPAIR/ IMPROVEMENT OF COMFORT ROOMS NUEVA VIZCAYA STATE UNIVERSITY, BAMBANG CAMPUS	 JOSEPH NEIL S. RUBIO Architect, Member Number: _____	 OFELIA S. RUBIO Architect, Member Number: _____ JYRUS YVES CADIENTE Director, APISDS	 GERALD L. PEREZ Campus Administrator	 CARLO F. VADIL VP for Planning, Development and Information System	 WILFREDO A. DUMALE, JR. University President	

TYPICAL MEN'S COMMON CR

S E C O N D F L O O R

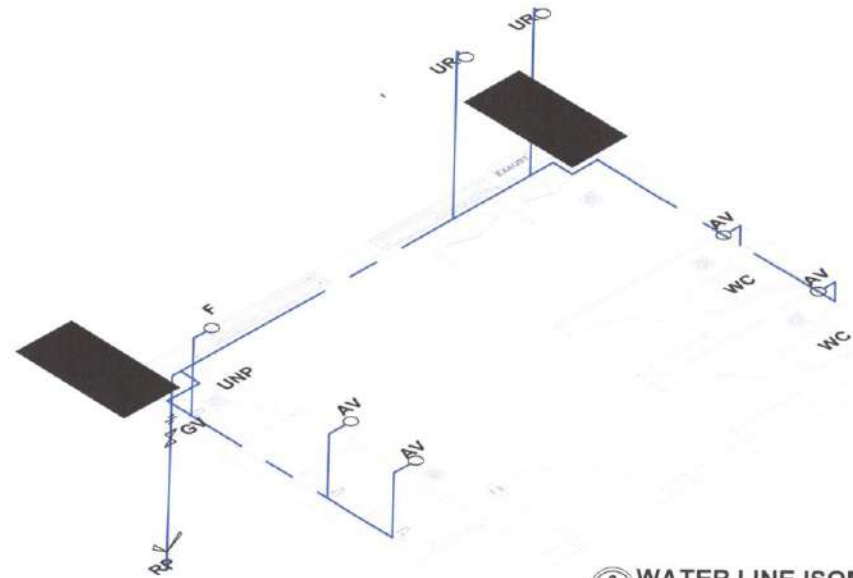

2 WATER LINE ISOMETRIC LAYOUT
P 9 SCALE: 1:30

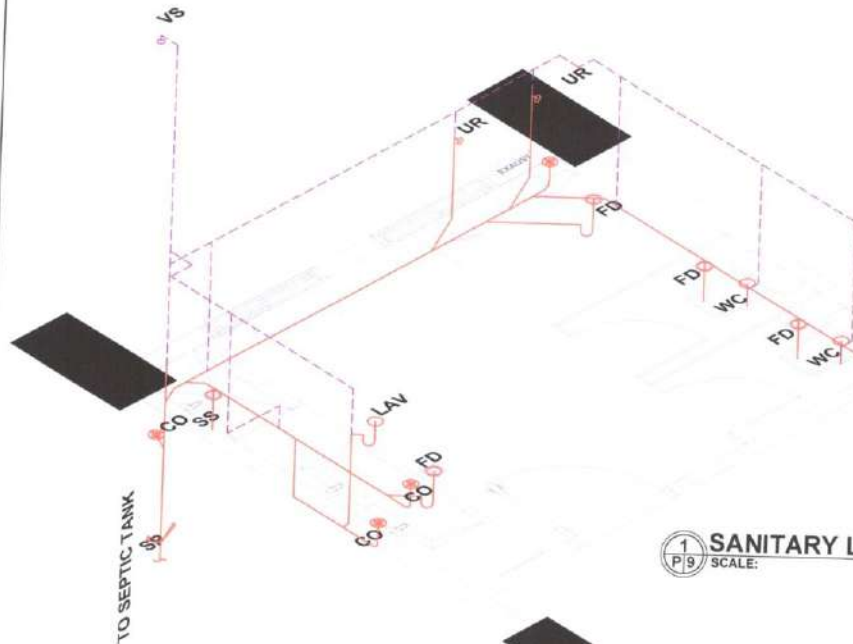

1 SANITARY LINE ISOMETRIC LAYOUT
P 9 SCALE: 1:30

LEGEND

SYMBOL	DESCRIPTION	SYMBOL	DESCRIPTION
	PIPE		FAUCET
	UNION PATENT		SHOWER
	GATE VALVE		KITCHEN SINK
	WATER LINE		LAVATORY
	CLEAN-OUT		WATER CLOSET
	VENT STACK		UNION PATENT
	GATE VALVE		CLEAN-OUT
	VENT PIPE		STACK PIPE
	ANGLE VALVE		RISE PIPE
	URINAL		


SIGNED AND SEALED BY:		PROJECT AND LOCATION:		PREPARED BY:		SUBMITTED BY:		CONCURRED BY:		RECOMMENDING APPROVAL:		APPROVED BY:		SHEET NO:	
PRC REG NO. _____ VALID UNTIL _____ PTR NO. _____ VALID UNTIL _____ PLACE OF ISSUE _____ DATE ISSUE _____ TRNG _____		REPAIR/ IMPROVEMENT OF COMFORT ROOMS NUEVA VIZCAYA STATE UNIVERSITY BAMBANG CAMPUS		 JOSEPH NEIL S. RUBIO Architect-Master Planner		 JYRUS JYLES CADIENTE Director, PPSSD		 GERALD L. PEREZ Campus Administrator		 CARLO F. VADIL VP for Planning, Development and Information Systems		 WILFREDO A. DUMALE, JR. University President			

TYPICAL LADIES' COMMON CR


S E C O N D F L O O R




VISUALIZATION

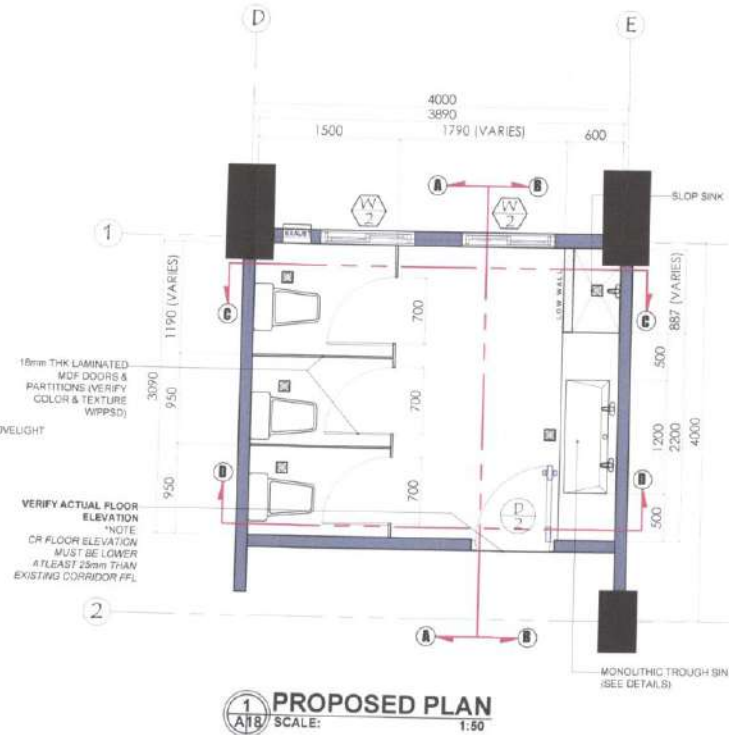

1 PROPOSED PLAN
SCALE: 1:50

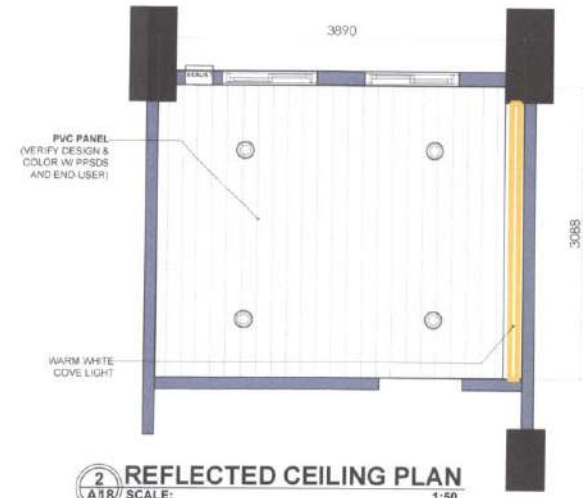

2 REFLECTED CEILING PLAN
SCALE: 1:50

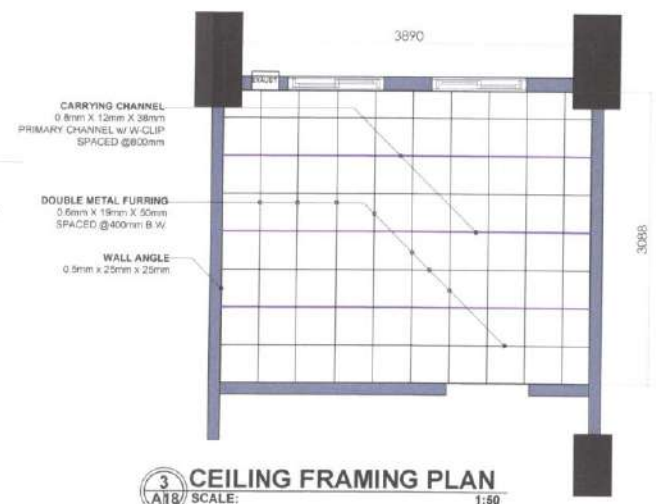


3 CEILING FRAMING PLAN
SCALE: 1:50


SIGNED AND SEALED BY:	PROJECT AND LOCATION:	PREPARED BY:	SUBMITTED BY:	CONCURRED BY:	RECOMMENDING APPROVAL:	APPROVED BY:	SHEET NO:
PWC REG NO: _____ VALID UNTL: _____ PTR NO: _____ VALID UNTL: _____ PLACE OF ISSUE: _____ DATE ISSUE: _____ TIN NO: _____	REPAIR/IMPROVEMENT OF COMFORT ROOMS NUUEVA VIZCAYA STATE UNIVERSITY, BAMBANG CAMPUS	DENNIS RO C VALDEZ JENNIE ROSE J. MORANTE	OFELIA S. RUBIO JYRUS VILES CADIENTE Director, PPGS	GERALD L. PEREZ Supervisor	CARLO F. VADIL VII for Planning Development and Information System	WILFREDO A. DUMALE, JR University President	A18 24

TYPICAL LADIES' COMMON CR


S E C O N D F L O O R

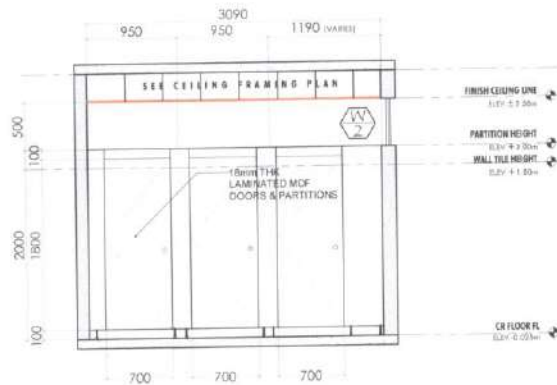


1 SECTION A
SCALE: 1:50

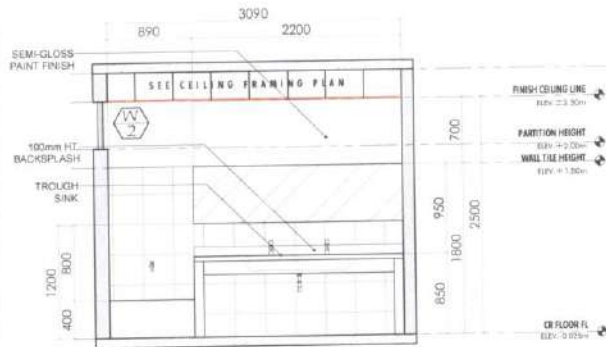

2 SECTION B
SCALE: 1:50

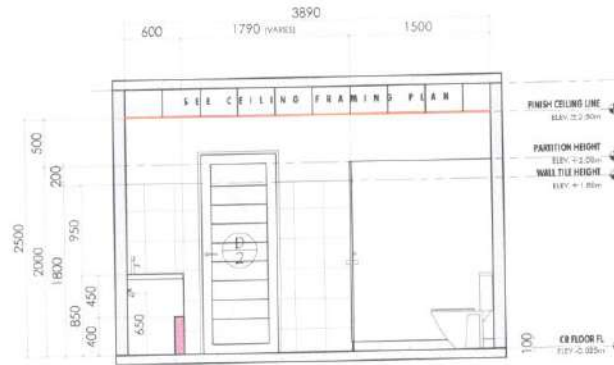

3 SECTION C
SCALE: 1:50

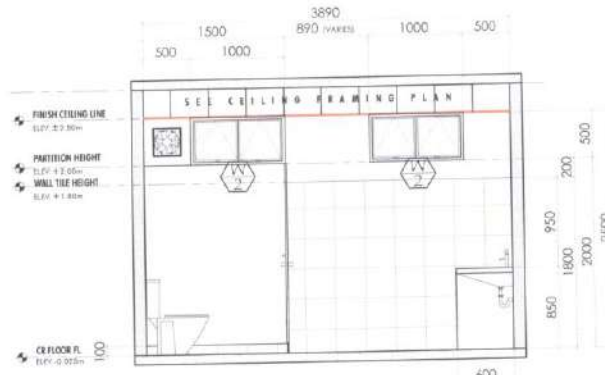

4 SECTION D
SCALE: 1:50

DOOR TYPE STEEL STAMPING FLUSH SWING DOOR WITH STEEL DOOR JAMB	WINDOW TYPE 2" THK TINTED GLASS & ALUMINUM FRAME AWNING WINDOW
DOOR SIZE (w x h) 800mm x 2100mm	WINDOW SIZE (w x h) 1000mm x 500mm
NO. OF DOORS 4 SETS	REGD NO. OF WINDOWS 8 SETS
LOCATION G FLR TO 2ND FLR. COMMON CRs	LOCATION G FLR TO 3RD FLR. COMMON CRs

5 SCHEDULE OF DOORS & WINDOWS (C)
SCALE: 1:50

SIGNED AND SEALED BY:

PROJECT AND LOCATION:

PREPARED BY:

SUBMITTED BY:

CONCURRED BY:

RECOMMENDING APPROVAL:

APPROVED BY:

SHEET NO:

PROJ. REG. NO. _____
PTR. NO. _____
PLACE OF ISSUE _____
TRNG _____



**REPAIR/IMPROVEMENT OF
COMFORT ROOMS**
NUEVA VIZCAYA STATE UNIVERSITY,
BAMBANG CAMPUS

DENNIS RIO J. VALDEZ
Architect

JENNIE ROSE J. MORANTE
Architect

OFELIA S. RUBIO
JYRUS J. CADIENTE
Check: PPSCS

GERALD L. PEREZ
Campus Administration



CARLO F. VADIL
VP for Planning, Development and Information System

 
 
 
WILFREDO A. DUMALE, JR.
University President

**A19
24**

TYPICAL LADIES' COMMON CR


S E C O N D F L O O R

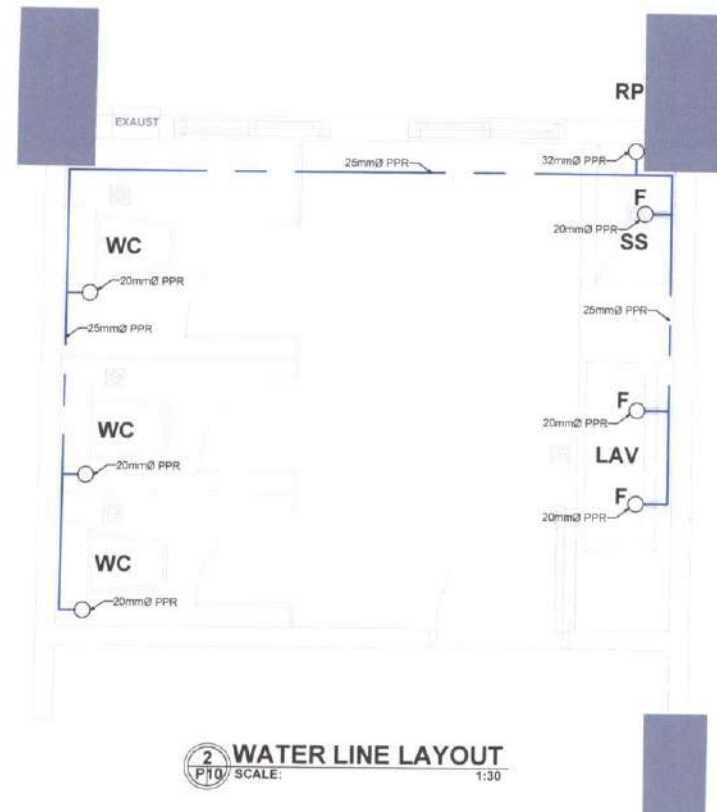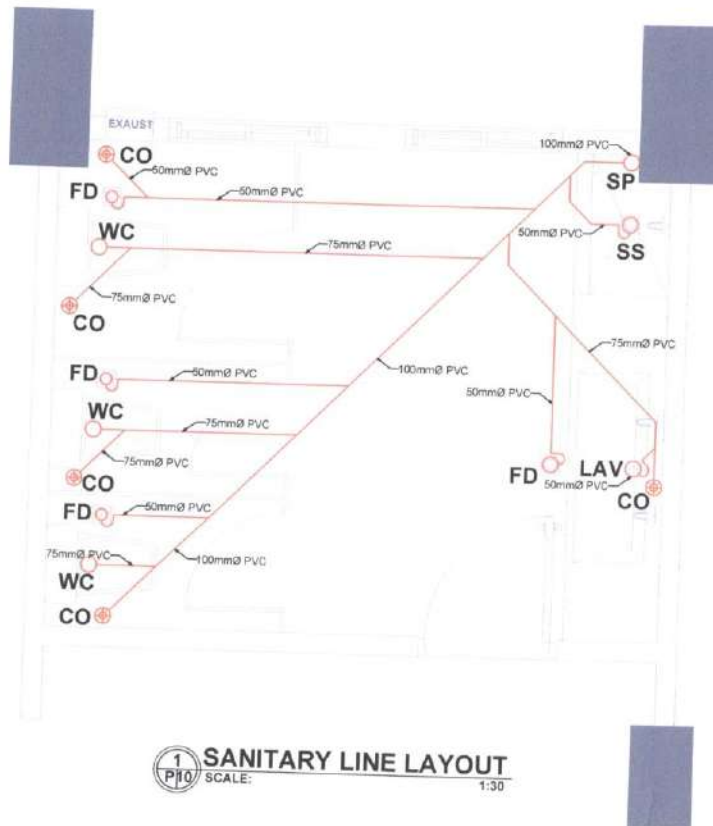

SIGNED AND SEALED BY:	PROJECT AND LOCATION:	PREPARED BY:	SUBMITTED BY:	CONCURRED BY:	RECOMMENDING APPROVAL:	APPROVED BY:	SHEET NO:
PRC REG NO: _____ VALID UNTIL: _____ PTR NO: _____ VALID UNTIL: _____ PLACE OF ISSUE: _____ DATE ISSUE: _____ TOWN: _____	 REPAIR/IMPROVEMENT OF COMFORT ROOMS NUEVA VIZCAYA STATE UNIVERSITY, BAMBING CAMPUS	 JOSEPH NEIL S. RUBIO Architect/ Master Number	 Ophelia S. RUBIO JYRUS JYKES CADIENTE Director, PRCOS	 GERARDO L. PEREZ Campus Administrator	 CARLO F. VADIL VP for Planning Development and Information System	 WILFREDO A. DUMALE, JR. University President	P 10 16

TYPICAL LADIES' COMMON CR

S E C O N D F L O O R

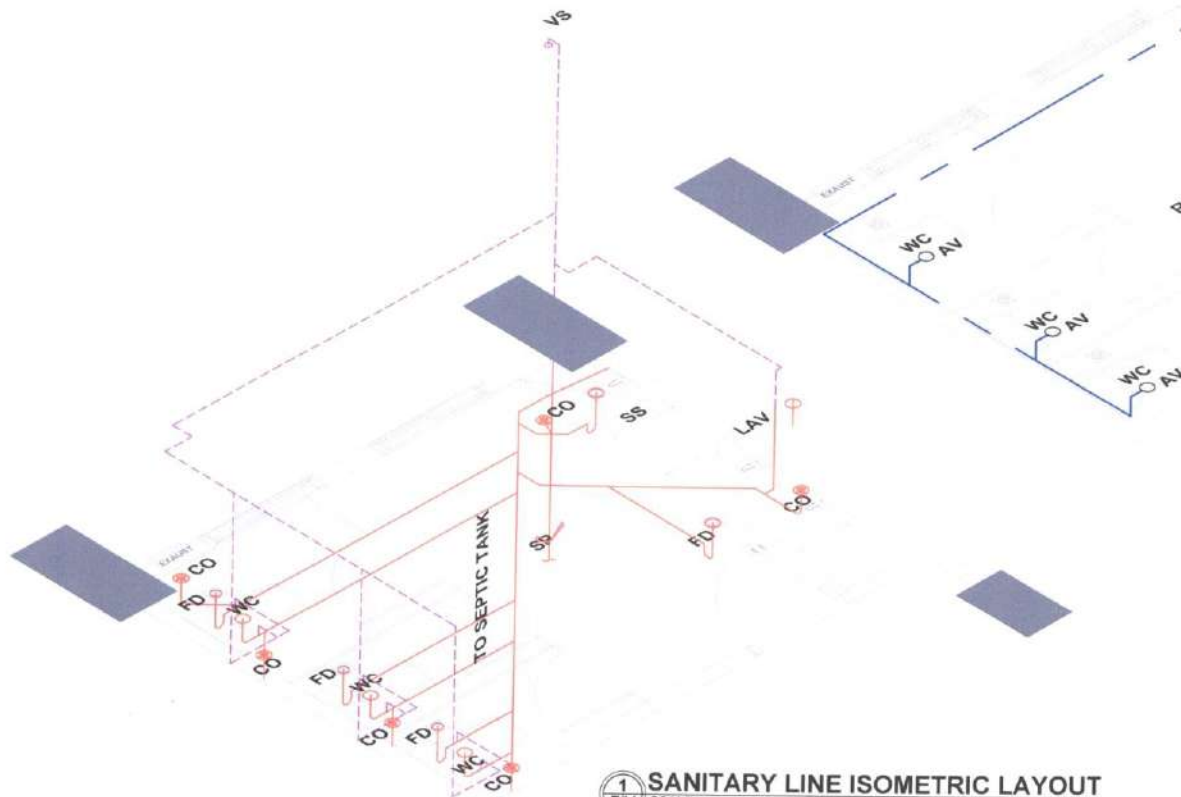

1 SANITARY LINE ISOMETRIC LAYOUT
SCALE: 1:30

2 WATER LINE ISOMETRIC LAYOUT
SCALE: 1:30

LEGEND

SYMBOL	DESCRIPTION	SYMBOL	DESCRIPTION
	PIPE OUTLET/INLET		SINK
	SHOWER		SHOWER
	GATE VALVE		KITCHEN SINK
	WATER LINE		LAVATORY
	P-TRAP		WATER CLOSET
	PIPE OUTLET/VENT		VENT STACK
	CLEAN-OUT BY COVER		JOINT
	DRAIN, WASTE, VENT		GATE VALVE
	VENT PIPE		SLOPE BREAK
	ANGLE VALVE		STACK PIPE
	URINAL		RISER PIPE

SIGNED AND SEALED BY:

PROJECT AND LOCATION:

PREPARED BY:

SUBMITTED BY:

CONCURRED BY:

RECOMMENDING APPROVAL:

APPROVED BY:

SHEET NO:

PRC REG NO. _____ VALID UNTIL _____
PTR NO. _____ VALID UNTIL _____
PLACE OF ISSUE _____ DATE ISSUED _____
TBM NO. _____



**REPAIR/IMPROVEMENT OF
COMFORT ROOMS**
NUEVA VIZCAYA STATE UNIVERSITY
BAMBANG CAMPUS

JOSEPH NEILS RUBIO
Assistant Municipal Engineer

JYRUS JYLES CADIENTE
Director, PPSOS




GERALD L. PEREZ
Campus Administrator

CARLO F. VADIL
VP for Planning, Development and Information System

WILFREDO A. DUMALE, JR.
University President

PIT
16


SUPPLY OFFICE CR SECOND FLOOR

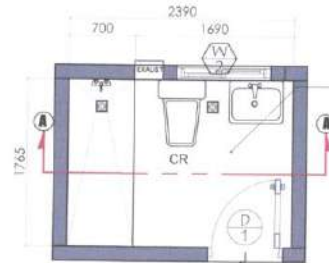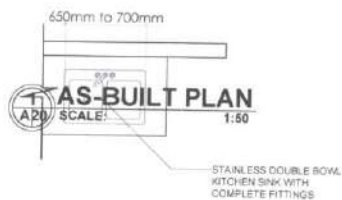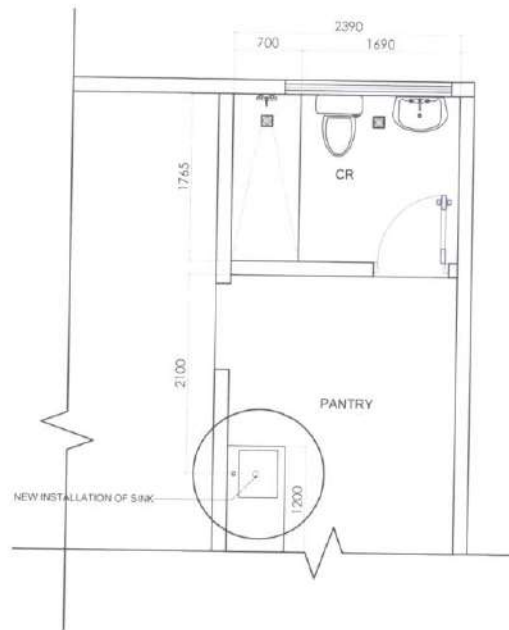

2 PROPOSED PLAN
SCALE: 1:50




4 REFLECTED CEILING PLAN
SCALE: 1:50

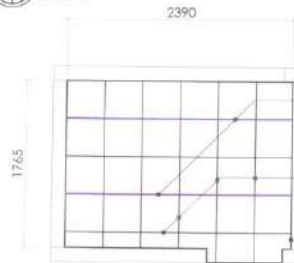

5 CEILING FRAMING PLAN
SCALE: 1:50

NOTE:
- SEE PIPING OF SANITARY AND WATER LINE (VERIFY ACTUAL)
- INSTALLATION OF NEW FURNITURE
- INSTALLATION OF NEW FLOOR AND WALL TILES
- CONDUIT FAN
- IMPROVE CEILING AND LIGHTING

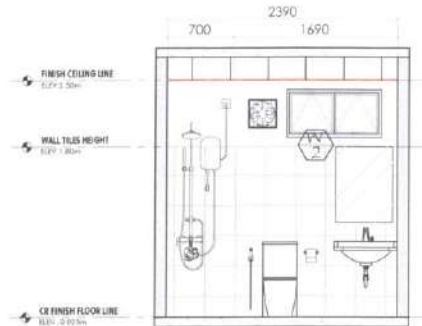

3 SECTION A
SCALE: 1:50


DOOR TYPE: PVC FLUSH DOOR W/ LOUVERS	WINDOW TYPE: 2" THK TINTED GLASS & ALUMINUM FRAME AWNING WINDOW
DOOR SIZE (W x H): 800mm x 2100mm	WINDOW SIZE (W x H): 1000mm x 500mm
NO OF DOORS: 1 PC	REQ'D NO OF WINDOWS: 1 PC
LOCATION: 2ND FLR. SUPPLY OFFICE	LOCATION: 2ND FLR. SUPPLY OFFICE

6 SCHEDULE OF DOORS & WINDOWS (D)
SCALE: 1:50

SIGNED AND SEALED BY:	PROJECT AND LOCATION:	PREPARED BY:	SUBMITTED BY:	CONCURRED BY:	RECOMMENDING APPROVAL:	APPROVED BY:	SHEET NO:
PRC REG NO. _____ VALID UNTIL _____ PTR NO. _____ VALID UNTIL _____ PLACE OF ISSUE _____ DATE OF ISSUE _____ TRV NO. _____	 REPAIR/IMPROVEMENT OF COMFORT ROOMS NUEVA VIZCAYA STATE UNIVERSITY, BAMBANG CAMPUS	DENNIS R. VALDEZ JENNIE ROSE J. MORANTE	OFELIA S. RUBIO JYRUS VILES CADIENTE CLERK: PRCDS	GERALD L. PEREZ Campus Administrator	CARLO F. VADIL VP for Planning, Development and Information Systems	WILFREDO A. DUMACE, JR. University President	A 20 24

SUPPLY OFFICE CR





SECOND FLOOR

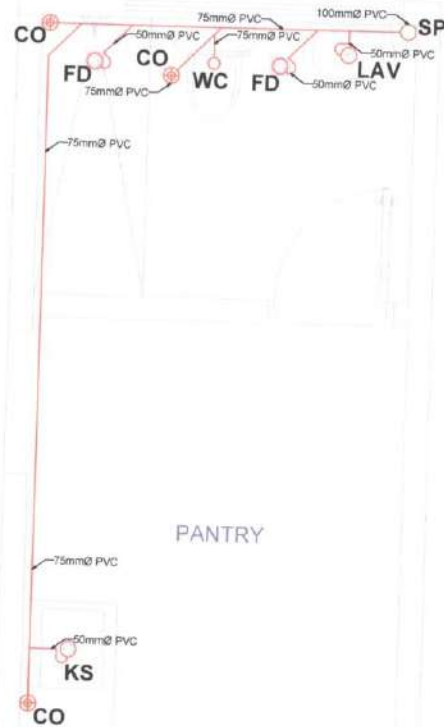

1 SANITARY LINE LAYOUT
SCALE: 1:30




    2 WATER LINE LAYOUT
SCALE: 1:30


SIGNED AND SEALED BY:	PROJECT AND LOCATION:	PREPARED BY:	SUBMITTED BY:	CONCURRED BY:	RECOMMENDING APPROVAL:	APPROVED BY:	SHEET NO:
PRC REG NO: _____ VALID UNTIL: _____ PTR NO: _____ VALID UNTIL: _____ PLACE OF ISSUE: _____ DATE ISSUE: _____ TIN NO: _____	 REPAIR/IMPROVEMENT OF COMFORT ROOMS NUEVA VIZCAYA STATE UNIVERSITY, BAMBANG CAMPUS	 JOSEPH NEIL S. RUBIO Architect/Master Planner	 JYRUS J. YBES Director, BPRSC	 GERALD L. PEREZ Campus Administrator	 CARLO F. VADIL VP for Planning, Development and Information Systems	 WILFREDO A. DUMALE, JR. University President	P 12 16

SUPPLY OFFICE CR

SECOND FLOOR

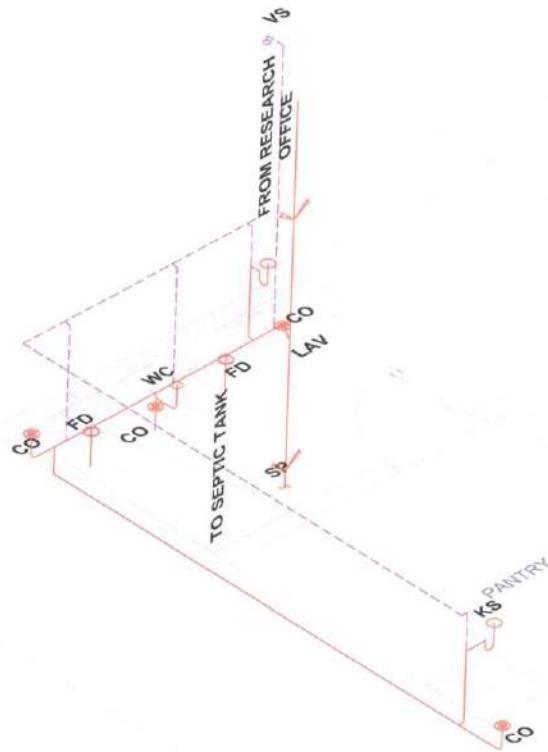

1 **SANITARY LINE ISOMETRIC LAYOUT**
SCALE: 1:30

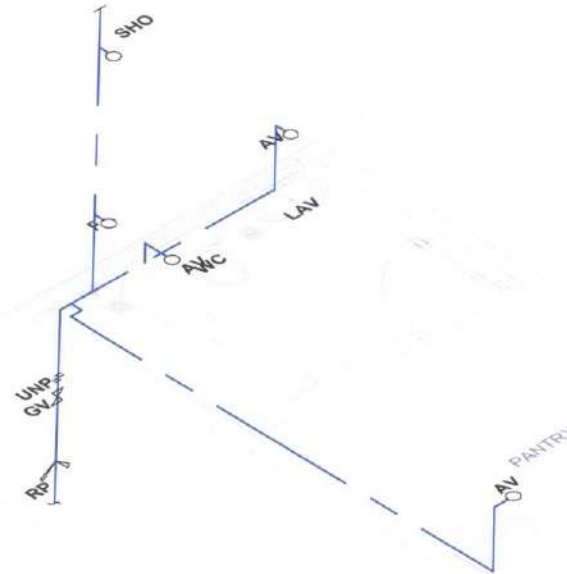

2 **WATER LINE ISOMETRIC LAYOUT**
SCALE: 1:30

LEGEND

SYMBOL	DESCRIPTION	SYMBOL	DESCRIPTION
—○—	PIPE OUTLET/INLET	F	FAUCET
≡	UPON PATENTE	SHO	SHOWER
⋈	GATE VALVE	KS	KITCHEN SINK
—	WATER LINE	LAV	LAVATORY
⌋	P-TRAP	WC	WATER CLOSET
—○—	PIPE OUTLET/INLET	VS	VENT STACK
⊕	CLEAN-OUT NO COVER	UNP	UPON PATENTE
—	RED WATER WITH WATER	GV	GATE VALVE
---	VENT PIPE	SS	SUPPLY PIPE
AV	ANGLE VALVE	SP	STACK PIPE
UR	JUNIAL	RP	ROOF LINE

SIGNED AND SEALED BY:

PROJECT AND LOCATION:

PREPARED BY:

SUBMITTED BY:

CONCURRED BY:

RECOMMENDING APPROVAL:

APPROVED BY:

SHEET NO:

PRC REG NO. _____ VALID UNTIL _____
PTR NO. _____ VALID UNTIL _____
PLACE OF ISSUE _____ DATE ISSUE _____
TRN NO. _____



**REPAIR/ IMPROVEMENT OF
COMFORT ROOMS**

NUEVA VIZCAYA STATE UNIVERSITY,
BANTING CAMPUS

JOSEPH NEIL S. RUBIO
Architect/MECHANICAL ENGINEER

JYRUS JYLOS CADIENTE
Director, RPSCS

GERALD L. PEREZ
Campus Administrator



CARLO F. VADIL
VP for Planning, Development and Information System

WILFREDO A. DUMALE JR.
University President

P13
16

RESEARCH OFFICE CR

T H I R D F L O O R

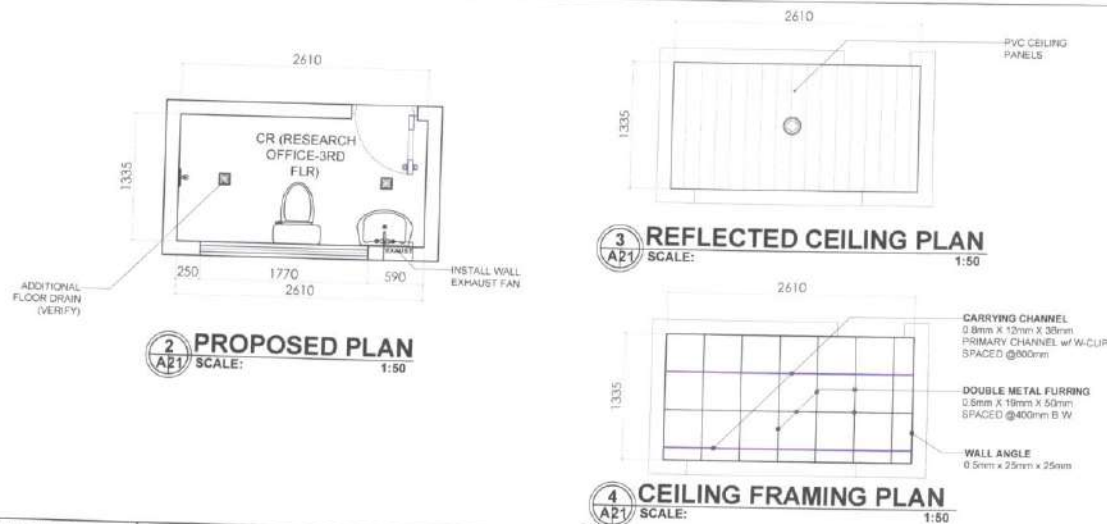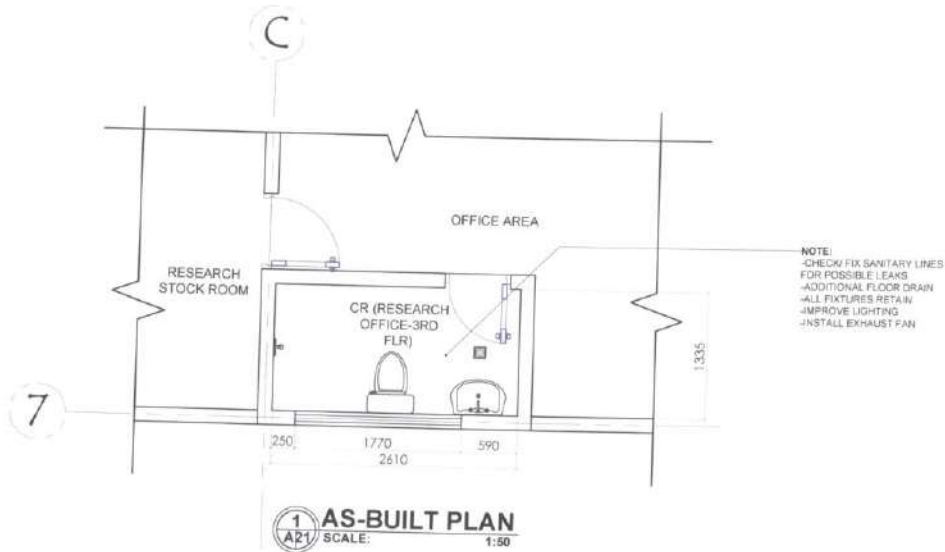

ACTUAL SITE


SIGNED AND SEALED BY:	PROJECT AND LOCATION:	PREPARED BY:	SUBMITTED BY:	CONCURRED BY:	RECOMMENDING APPROVAL:	APPROVED BY:	SHEET NO:
PRC REG NO: _____ VALID UNTIL: _____ PTR NO: _____ VALID UNTIL: _____ PLACE OF ISSUE: _____ DATE ISSUE: _____ TIN NO: _____	REPAIR/ IMPROVEMENT OF COMFORT ROOMS NUUEVA VIZCAYA STATE UNIVERSITY BAMBANG CAMPUS	DENNIS RICO VALDEZ Architect JENNIE ROSE J. MORANTE Architect	OFFICIA S. RUBIO Civil Engineer JYRUS JILES CADIENTE Director, PPSDS	GERALD L. PEREZ Campus Administrator	CARLO F. VADIL VP for Planning, Development and Information System	WILFREDO A. DUMALE, JR. University President	A 21 24

RESEARCH OFFICE CR


T H I R D F L O O R

LEGEND


SYMBOL	DESCRIPTION	SYMBOL	DESCRIPTION
	PIPE OUTLET/INLET	F	FACET
	UNION PATENT	SHO	SHOWER
	GATE VALVE	KS	KITCHEN SINK
	WATER LINE	LAV	LAVATORY
	FLOOR DRAIN	WC	WATER CLOSET
	FIRE OUTLET/INLET	VS	VENT STACK
	CLEAN-OUT W/ COVER	UNP	UNION PATENT
	ROUGH-IN W/ NO COVER	GV	GATE VALVE
	VENT PIPE	SS	SCOT SINK
	ANGLE VALVE	SP	STACK PIPE
	URINAL	RP	RISEN PIPE

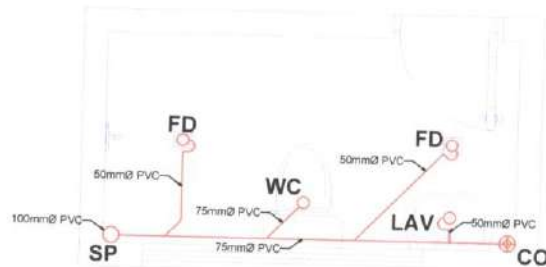


1 SANITARY LINE LAYOUT
SCALE: 1:30

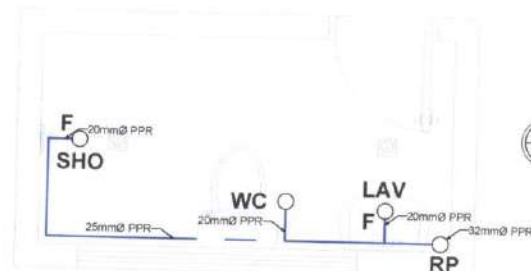

2 WATER LINE LAYOUT
SCALE: 1:30

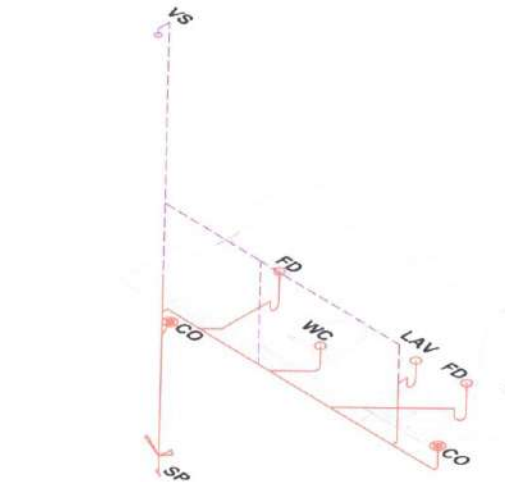


3 SANITARY LINE ISOMETRIC LAYOUT
SCALE: 1:30

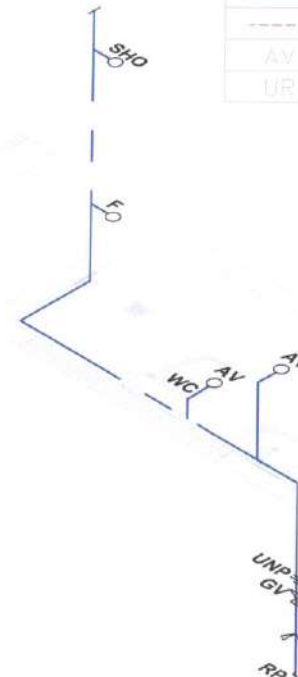


4 WATER LINE ISOMETRIC LAYOUT
SCALE: 1:30

SIGNED AND SEALED BY:		PROJECT AND LOCATION:		PREPARED BY:		SUBMITTED BY:		CONCURRED BY:		RECOMMENDING APPROVAL:		APPROVED BY:		SHEET NO:	
PRC REG NO. _____ VALID UNTIL _____ PPR NO. _____ DATE OF ISSUE _____ TIN NO. _____		REPAIR/ IMPROVEMENT OF COMFORT ROOMS NUEVA VIZCAYA STATE UNIVERSITY, BAMBIAG CAMPUS		 JOSEPH NEIL S. RUBIO Architect/ Master Plumber		 OFELIA S. RUBIO Civil Engineer JYRUS JYLES CADIENTE Director, PPSDS		 GERALD L. PEREZ Campus Administrator		 CARLO F. VADIL VP for Planning, Development and Information System		 WILFREDO A. DUMALE, JR. University President		P 14 16	

GUEST ROOM CR THIRD FLOOR

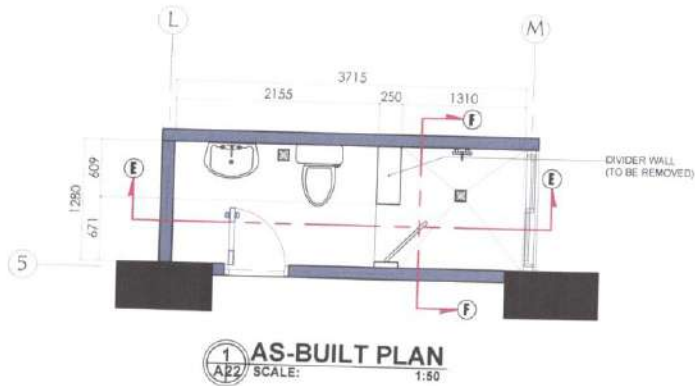

ACTUAL SITE

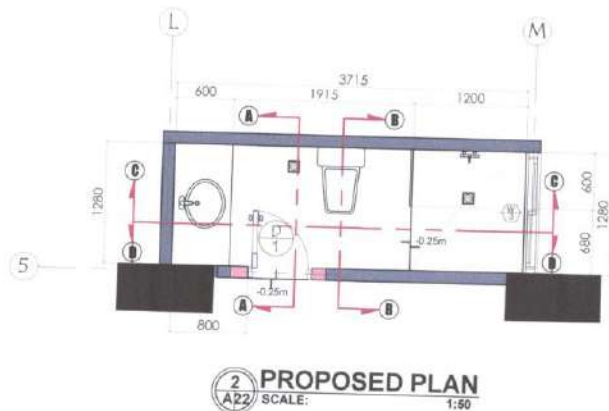


VISUALIZATION


SIGNED AND SEALED BY:	PROJECT AND LOCATION:		PREPARED BY:		SUBMITTED BY:	CONCURRED BY:	RECOMMENDING APPROVAL:	APPROVED BY:	SHEET NO:	
PRC REG NO: _____ PTR NO: _____ PLACE OF ISSUE: _____ DATE OF ISSUE: _____ TTN NO: _____		REPAIR/IMPROVEMENT OF COMFORT ROOMS NUEVA VIZCAYA STATE UNIVERSITY, BAMBANG CAMPUS	 DENNIS MO C. VALDEZ Architect	 JENNIE ROSE J. MORANTE Architect	 OFELIA S. RUBIO Architect	 JYRUS P. CABIENTE Campus Administrator	 GERALD L. PEREZ Campus Administrator	 CARLO F. VADIL VP for Planning, Development and Information System	 WILFREDO A. DUMALE, JR. University President	A 22 24

GUEST ROOM CR THIRD FLOOR

AS-BUILT

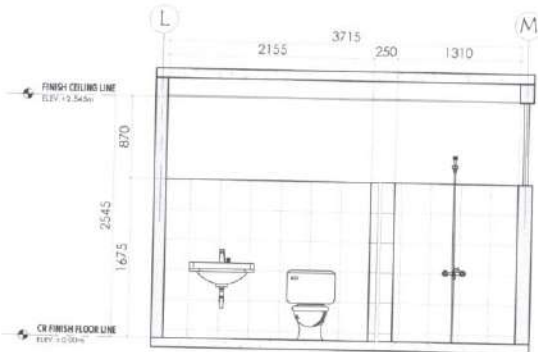


1 SECTION E
SCALE: 1:50

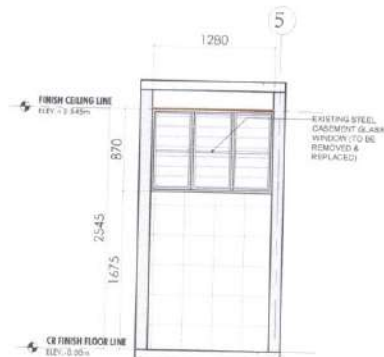


2 SECTION F
SCALE: 1:50


PROPOSED

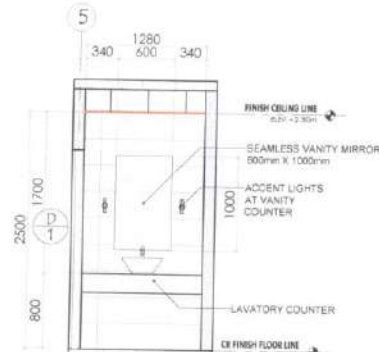



3 SECTION A
SCALE: 1:50

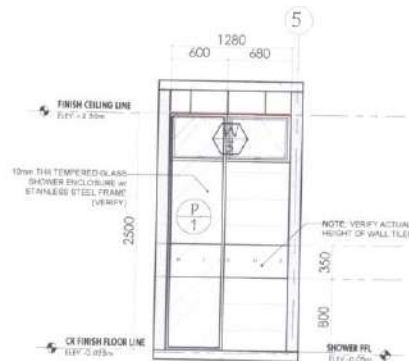

4 SECTION B
SCALE: 1:50

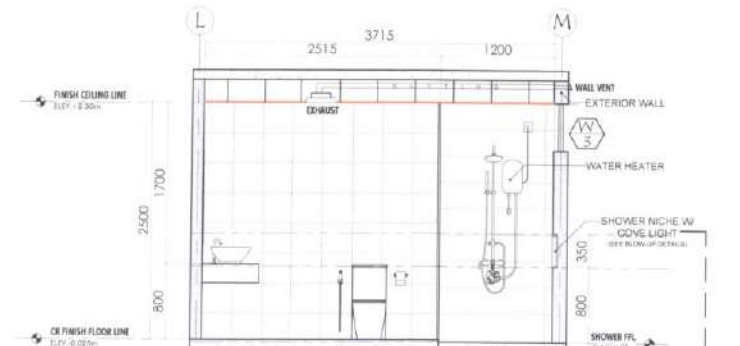

5 SECTION C
SCALE: 1:50

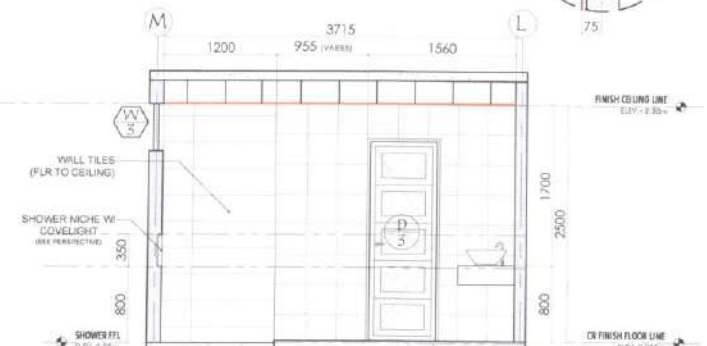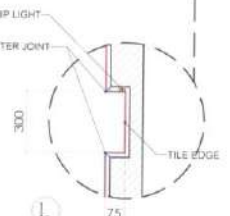


6 SECTION D
SCALE: 1:50

SIGNED AND SEALED BY: DENNIS RIO C. VALDEZ Licensed Professional Engineer	PROJECT AND LOCATION: REPAIR/IMPROVEMENT OF COMFORT ROOMS NUEVA VISCAYA STATE UNIVERSITY BAMBANG CAMPUS	PREPARED BY: JENNIE ROSE J. MORANTE Architect	SUBMITTED BY: JYRUS JYLES CADIENTE Architect	CONCURRED BY: GERALD L. PEREZ Campus Administrator	RECOMMENDING APPROVAL: CARLO F. VADIL VP for Planning, Development and Information System	APPROVED BY: WIFREDO A. DUMALE, JR. University President	SHEET NO: A 23 24
---	--	---	--	--	---	--	--


PRG REG NO: _____ VALID UNTIL: _____
 PTR NO: _____ VALID UNTIL: _____
 PLACE OF ISSUE: _____ DATE ISSUE: _____
 TIN NO: _____

GUEST ROOM CR

THIRD FLOOR

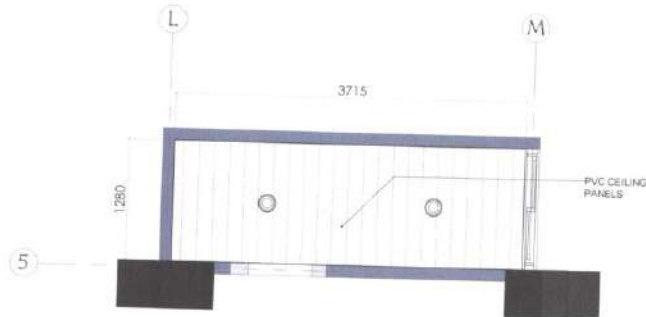

1 REFLECTED CEILING PLAN
SCALE: 1:50

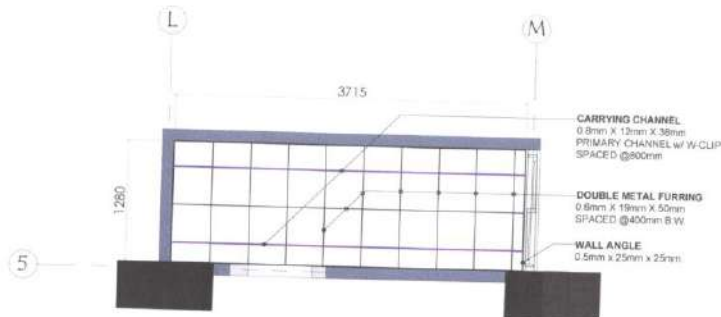

2 CEILING FRAMING PLAN
SCALE: 1:50


DOOR TYPE: SWING DOOR, FROSTED GLASS AND ALUMINUM DOOR.	WINDOW TYPE: 2" THK TINTED GLASS & ALUMINUM FRAME AWNING WINDOW	PARTITION TYPE: 10mm THK TEMPERED GLASS W/ STAINLESS STEEL FRAME
DOOR SIZE (W x H): 700mm x 2100mm	WINDOW SIZE (W x H): 1000mm x 500mm	PARTITION SIZE (W x H): 600mm x 2500mm
NO. OF DOORS: 1 SET	REQ'D NO. OF WINDOWS: 1 SET	REQ'D NO. OF PARTITION: 1 SET
LOCATION: 3RD FLR, GUEST ROOM CR	LOCATION: GUEST ROOM CR	LOCATION: GUEST ROOM CR

3 SCHEDULE OF DOORS & WINDOWS (E)
SCALE: 1:50


SIGNED AND SEALED BY:		PROJECT AND LOCATION:		PREPARED BY:		SUBMITTED BY:		CONCURRED BY:		RECOMMENDING APPROVAL:		APPROVED BY:		SHEET NO:	
 DENNIS RIO A. VALDEZ PROJECT		 REPAIR/IMPROVEMENT OF COMFORT ROOMS NUEVA VIZCAYA STATE UNIVERSITY, BAMBANG CAMPUS		 JENNIE ROSE J. MORANTE CHECKED		 OFELIA S. AMB CHECKED JYRUS JYRUS CADIENTE OFFICE - PPSCS		 GERALD L. PABEZ SENIOR ADMINISTRATOR		 CARLO F. VADIL VP for Planning, Development and Information System		 WILFREDO A. DUMALE, JR. UNIVERSITY PRESIDENT			
PROJ. RES. NO. _____ VALID UNTIL: _____ PTR. NO. _____ VALID UNTIL: _____ PLACE OF ISSUE: _____ DATE ISSUE: _____ TIN NO. _____															

GUEST ROOM CR



THIRD FLOOR

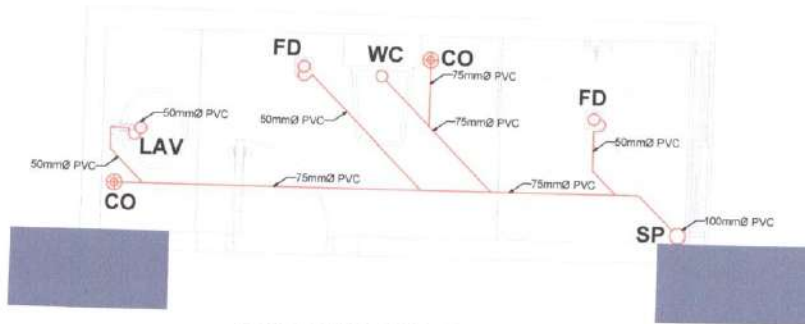

1 SANITARY LINE LAYOUT
SCALE: 1:30

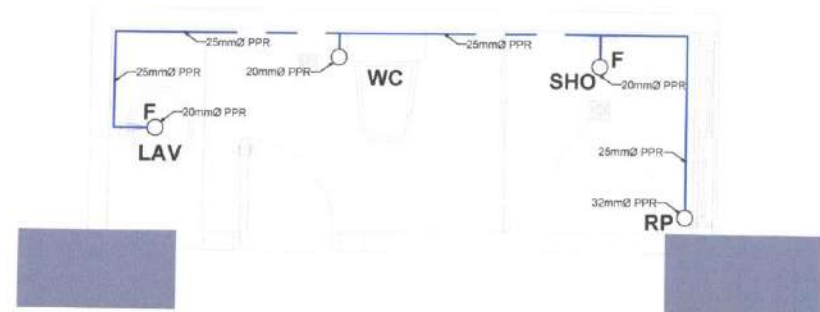


2 WATER LINE LAYOUT
SCALE: 1:30

  
SIGNED AND SEALED BY:	PROJECT AND LOCATION:	PREPARED BY:	SUBMITTED BY:	CONCURRED BY:	RECOMMENDING APPROVAL:	APPROVED BY:	SHEET NO.:
PRG REG NO. _____ VALID UNTL _____ PTR NO. _____ VALID UNTL _____ PLACE OF ISSUE _____ DATE ISSUE _____ TITLING _____	 REPAIR/IMPROVEMENT OF COMFORT ROOMS NUEVA VIZCAYA STATE UNIVERSITY BAMBANG CAMPUS	 JOSEPH NEIL S. RUBIO Architect/ Master Plumber	 JYRUS JYLES CADIENTE Director, PRCS	 GERALD L. PEREZ Campus Administrator	 CARLO F. VADIL VP for Planning, Development and Information Systems	 WILFREDO A. DUMALE, JR. University President	P 15 16

GUEST ROOM CR

THIRD FLOOR

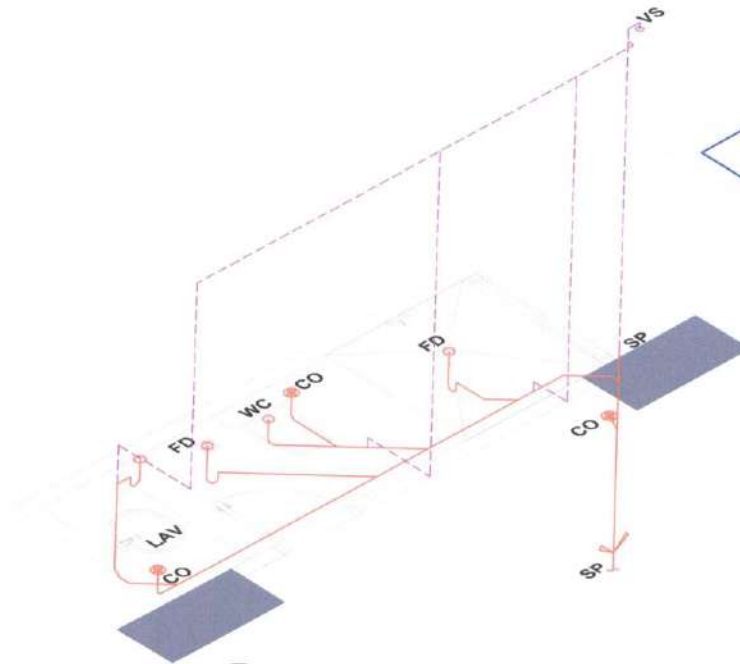

1 SANITARY LINE ISOMETRIC LAYOUT
SCALE: 1:30

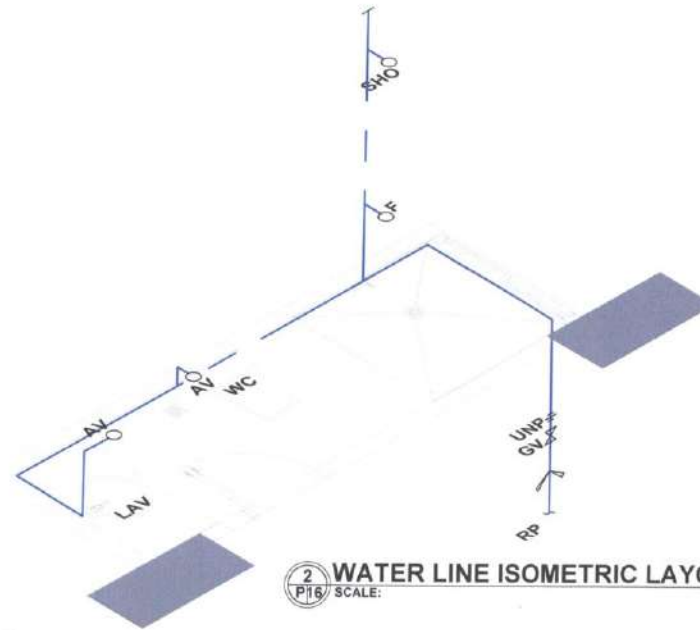

2 WATER LINE ISOMETRIC LAYOUT
SCALE: 1:30

LEGEND

SYMBOL	DESCRIPTION	SYMBOL	DESCRIPTION
	PIPE	F	FAUCET
	SHOWER	SHO	SHOWER
	GATE VALVE	KS	KITCHEN SINK
	WATER LINE	LAV	LAVATORY
	P-TRAP	WC	WATER CLOSET
	PIPE OUTLET/FAN	VS	VENT STACK
	CLEAN-OUT W/ STOP	UNP	URINAL PATENT
	ROUGH WATER/WALL WATER	GV	GATE VALVE
	VENT PIPE	SS	SLOPPING
AV	AVAIL VALVE	SP	STACK PIPE
UR	URINAL	RP	RISER PIPE

SIGNED AND SEALED BY:

PROJECT AND LOCATION:

PREPARED BY:

SUBMITTED BY:

CONCURRED BY:

RECOMMENDING APPROVAL:

APPROVED BY:

SHEET NO:

PRC REG NO: _____ VALID UNTIL: _____
PTR NO: _____ VALID UNTIL: _____
PLACE OF ISSUE: _____ DATE ISSUE: _____
TR NO: _____



**REPAIR/IMPROVEMENT OF
COMFORT ROOMS**
NUEVA VIZCAYA STATE UNIVERSITY,
BAMBANG CAMPUS

JOSEPH NEL S. RUBIO
Architect/Master Plumber

JYRUS JYLES CADIENTE
Director, PPQS

GERALD L. PEREZ
Campus Administrator


CARLO F. VADIL
VP for Planning, Development and Information Systems

WILFREDO A. DUMALE, JR.
University President


P 16
16

BUDGET OFFICE (NEW CR)

G R O U N D F L O O R

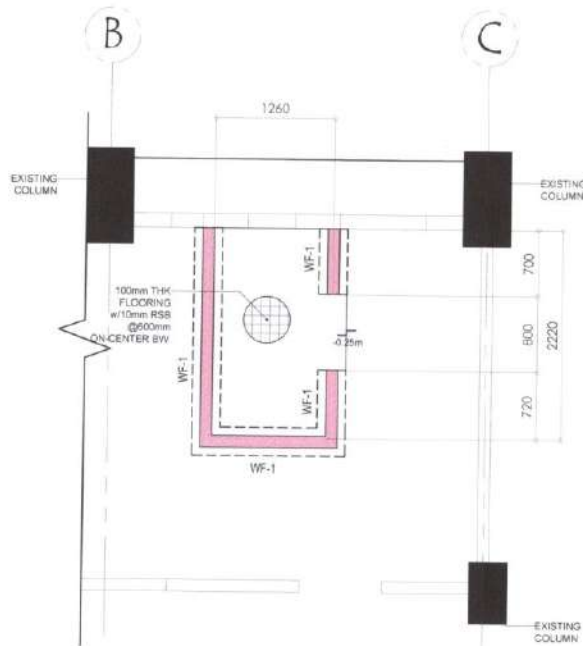

1
S1 WALL FOOTING PLAN
SCALE: 1:50

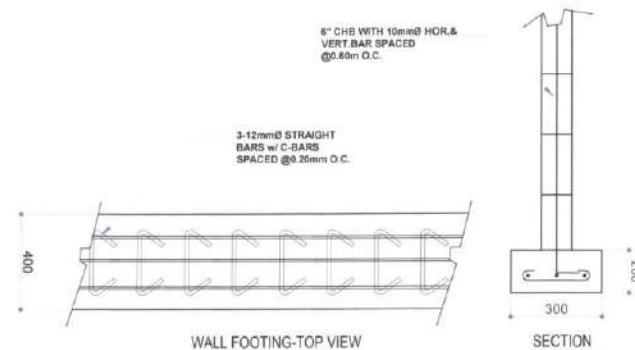


WF-1


2
S1 WALL FOOTING DETAILS
SCALE: NTS

SIGNED AND SEALED BY:	PROJECT AND LOCATION:	PREPARED BY:	SUBMITTED BY:	CONCURRED BY:	RECOMMENDING APPROVAL:	APPROVED BY:	SHEET NO:
PRC REG NO. _____ VALID UNTIL: _____ PTR NO. _____ VALID UNTIL: _____ PLACE OF ISSUE: _____ DATE ISSUE: _____ TIN NO. _____	 REPAIR/ IMPROVEMENT OF COMFORT ROOMS NUEVA VIZCAYA STATE UNIVERSITY, BAMBANG CAMPUS	DENNIS RICO VALDEZ <i>(Signature)</i> JENNIE ROSE J. MORANTE <i>(Signature)</i>	OFELIA S. RUBIO <i>(Signature)</i> JYRUS JYLES CADIENTE Director, PPSOS	GERALD L. PEREZ <i>(Signature)</i> Campus Administrator	CARLO F. VADIL <i>(Signature)</i> VP for Planning, Development and Information System	WILFREDO A. DUMALE, JR. <i>(Signature)</i> University President	S1 2


MEN & LADIES' COMMON CR (TROUGH SINK DETAILS) GROUND TO SECOND FLOOR

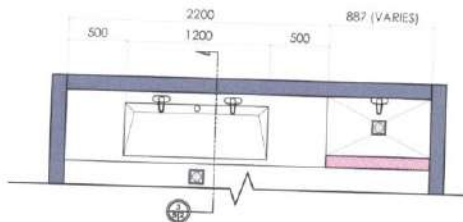


1 TROUGH SINK BLOW-UP PLAN
SCALE: 1:40

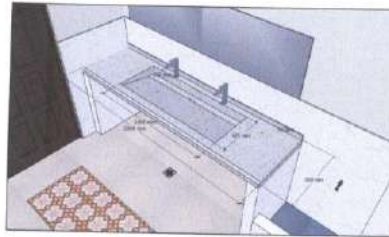


VISUALIZATION 1

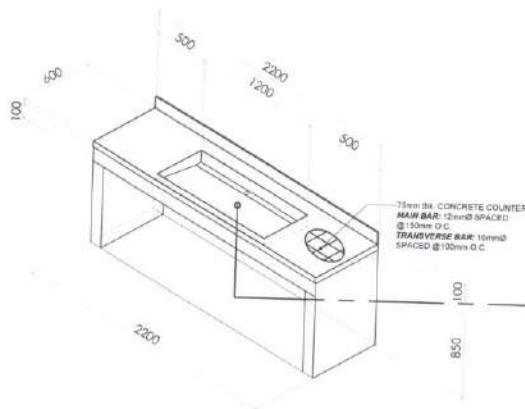


2 TROUGH SINK ISOMETRIC VIEW
SCALE: 1:40

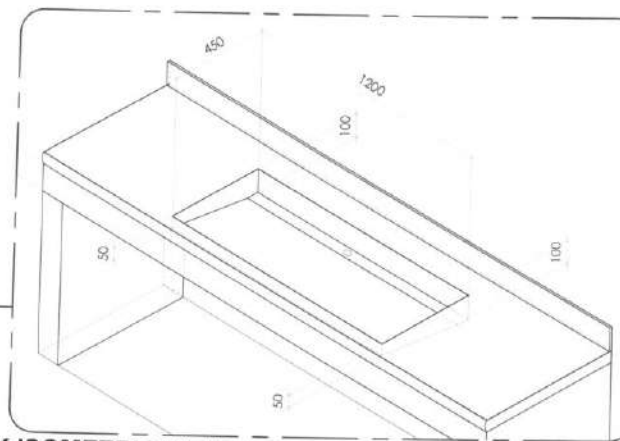


NTS

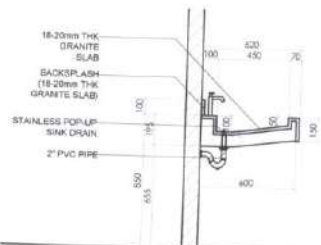

3 SECTION DETAILS
SCALE: 1:40

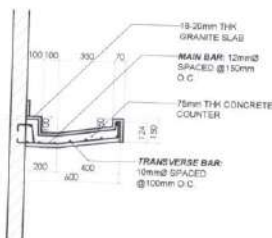


NTS

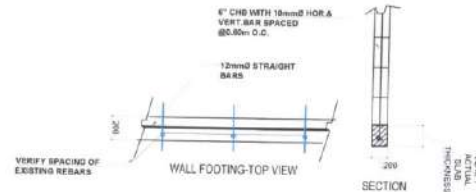

4 WALL FOOTING 2 DETAILS
SCALE: 1:40





VISUALIZATION 2

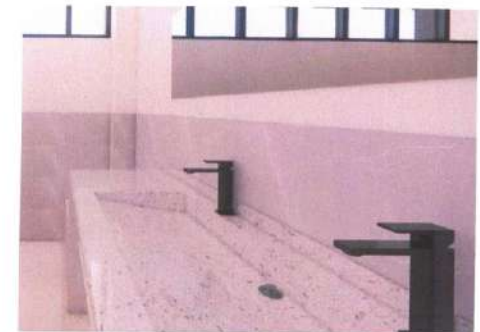


SIGNED AND SEALED BY:		PROJECT AND LOCATION:		PREPARED BY:		SUBMITTED BY:		CONCURRED BY:		RECOMMENDING APPROVAL:		APPROVED BY:		SHEET NO:	
PRG REG NO. _____ VALID UNTIL _____ PTR NO. _____ VALID UNTIL _____ PLACE OF ISSUE _____ DATE ISSUE _____ TRIND _____		 REPAIR/IMPROVEMENT OF COMFORT ROOMS RUPA WIZAYA STATE UNIVERSITY BAMBANG CAMPUS		 DENNIS RICO C. VALDEZ Architect  JENNIE ROSE J. MORANTE Architect		 OFELIA S. RUBIO Architect  JYRUS JYNE CADIENTE Director, PRC/CSO		 GERALD L. PEREZ Campus Administrator		 CARLO F. VADIL VP for Planning, Development and Information Systems		 WILFREDO A. DUMALE, JR. University President			

LIGHTING LAYOUT



GROUND FLOOR

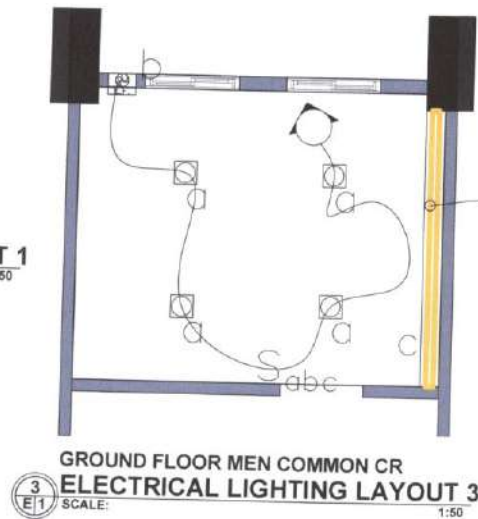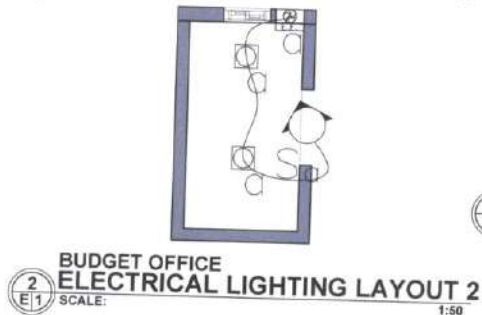

COVE LIGHT AT
CEILING

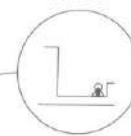


COVE LIGHT AT
CEILING

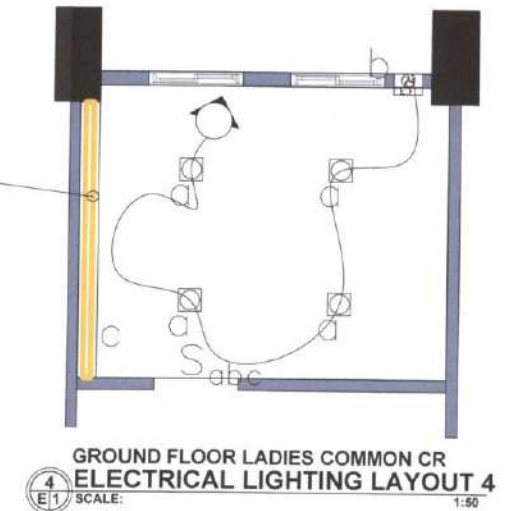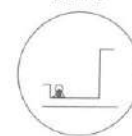



SIGNED AND SEALED BY:	PROJECT AND LOCATION:	PREPARED BY:	SUBMITTED BY:	CONCURRED BY:	RECOMMENDING APPROVAL:	APPROVED BY:	SHEET NO:
PRC REG NO. _____ VALID UNTIL: _____ PTR NO. _____ VALID UNTIL: _____ PLACE OF ISSUE: _____ DATE ISSUE: _____ TIN NO. _____	 REPAIR/ IMPROVEMENT OF COMFORT ROOMS NUUEVA VIZCAYA STATE UNIVERSITY, BAMBANG CAMPUS	<i>Kyle Benzon Galapon</i> KYLE BENZON GALAPON Electric Engineer	<i>Ofelia S. Rubio</i> OFELIA S. RUBIO Civil Engineer JYRUS JILES CADIENTE Director, PPSOS	<i>Gerald L. Perez</i> GERALD L. PEREZ Campus Administrator	<i>Carlo F. Vadil</i> CARLO F. VADIL VP for Planning, Development and Information Systems	<i>Wilfredo A. Dumale, Jr.</i> WILFREDO A. DUMALE, JR. University President	E 1 2

LIGHTING LAYOUT


SECOND FLOOR

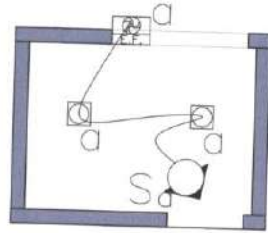


SUPPLY OFFICE CR
ELECTRICAL LIGHTING LAYOUT 5
 SCALE: 1:50

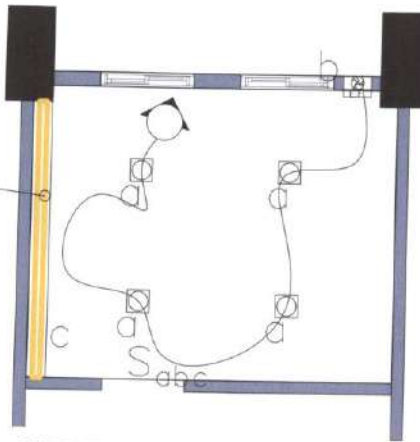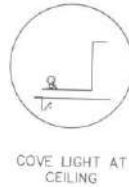

2ND FLR. MEN'S COMMON CR
ELECTRICAL LIGHTING LAYOUT 6
 SCALE: 1:50

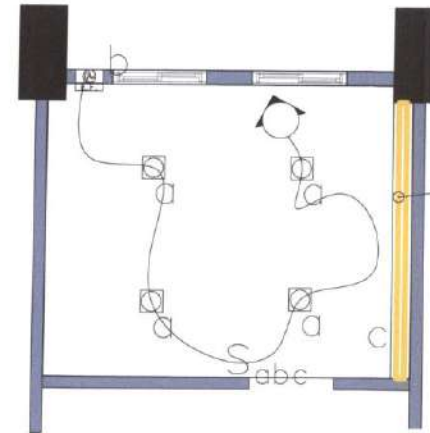


2ND FLR. LADIES' COMMON CR
ELECTRICAL LIGHTING LAYOUT 7
 SCALE: 1:50

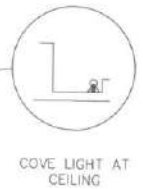


LIGHTING LAYOUT

THIRD FLOOR



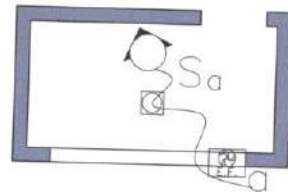


RESEARCH OFFICE CR
ELECTRICAL LIGHTING LAYOUT 8
 SCALE: 1:50

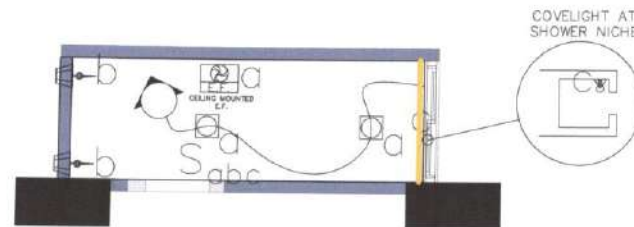

GUEST ROOM CR
ELECTRICAL LIGHTING LAYOUT 9
 SCALE: 1:50

   COVELIGHT AT SHOWER NICHE

SIGNED AND SEALED BY:	PROJECT AND LOCATION:	PREPARED BY:	SUBMITTED BY:	CONCURRED BY:	RECOMMENDING APPROVAL:	APPROVED BY:	SHEET NO:
PRC REG NO. _____ PTR NO. _____ PLACE OF ISSUE: _____ TRNO: _____	 REPAIR/ IMPROVEMENT OF COMFORT ROOMS NUEVA VIZCAYA STATE UNIVERSITY, BAMBANG CAMPUS	 KYLE RENZO A. GALAPON Electrical Engineer	 OFELIA S. RESON Chief Engineer JYRUS JYLES CADIENTE Director, RPQSD	 GERALD L. PEREZ Campus Administrator	 CARL F. VADIL VP for Planning, Development and Information System	 WILFREDO A. DUMALE, JR. University President	